


NOTE :
WRITTEN DIMENSIONS ON THESE DRAWINGS SHALL HAVE PRECEDENCE OVER SCALED DIMENSIONS.
CONTRACTORS SHALL VERIFY AND BE RESPONSIBLE FOR ALL DIMENSIONS SHOWN ON THESE DRAWINGS.
ANY DISCREPANCY ON ALL DRAWINGS & SPECIFICATIONS SHALL BE THE RESPONSIBILITY OF THE CONTRACTOR.
ANY DISCREPANCY ON ALL DRAWINGS & SPECIFICATIONS SHALL BE THE RESPONSIBILITY OF THE CONTRACTOR.
ANY DISCREPANCY ON ALL DRAWINGS & SPECIFICATIONS SHALL BE THE RESPONSIBILITY OF THE CONTRACTOR.

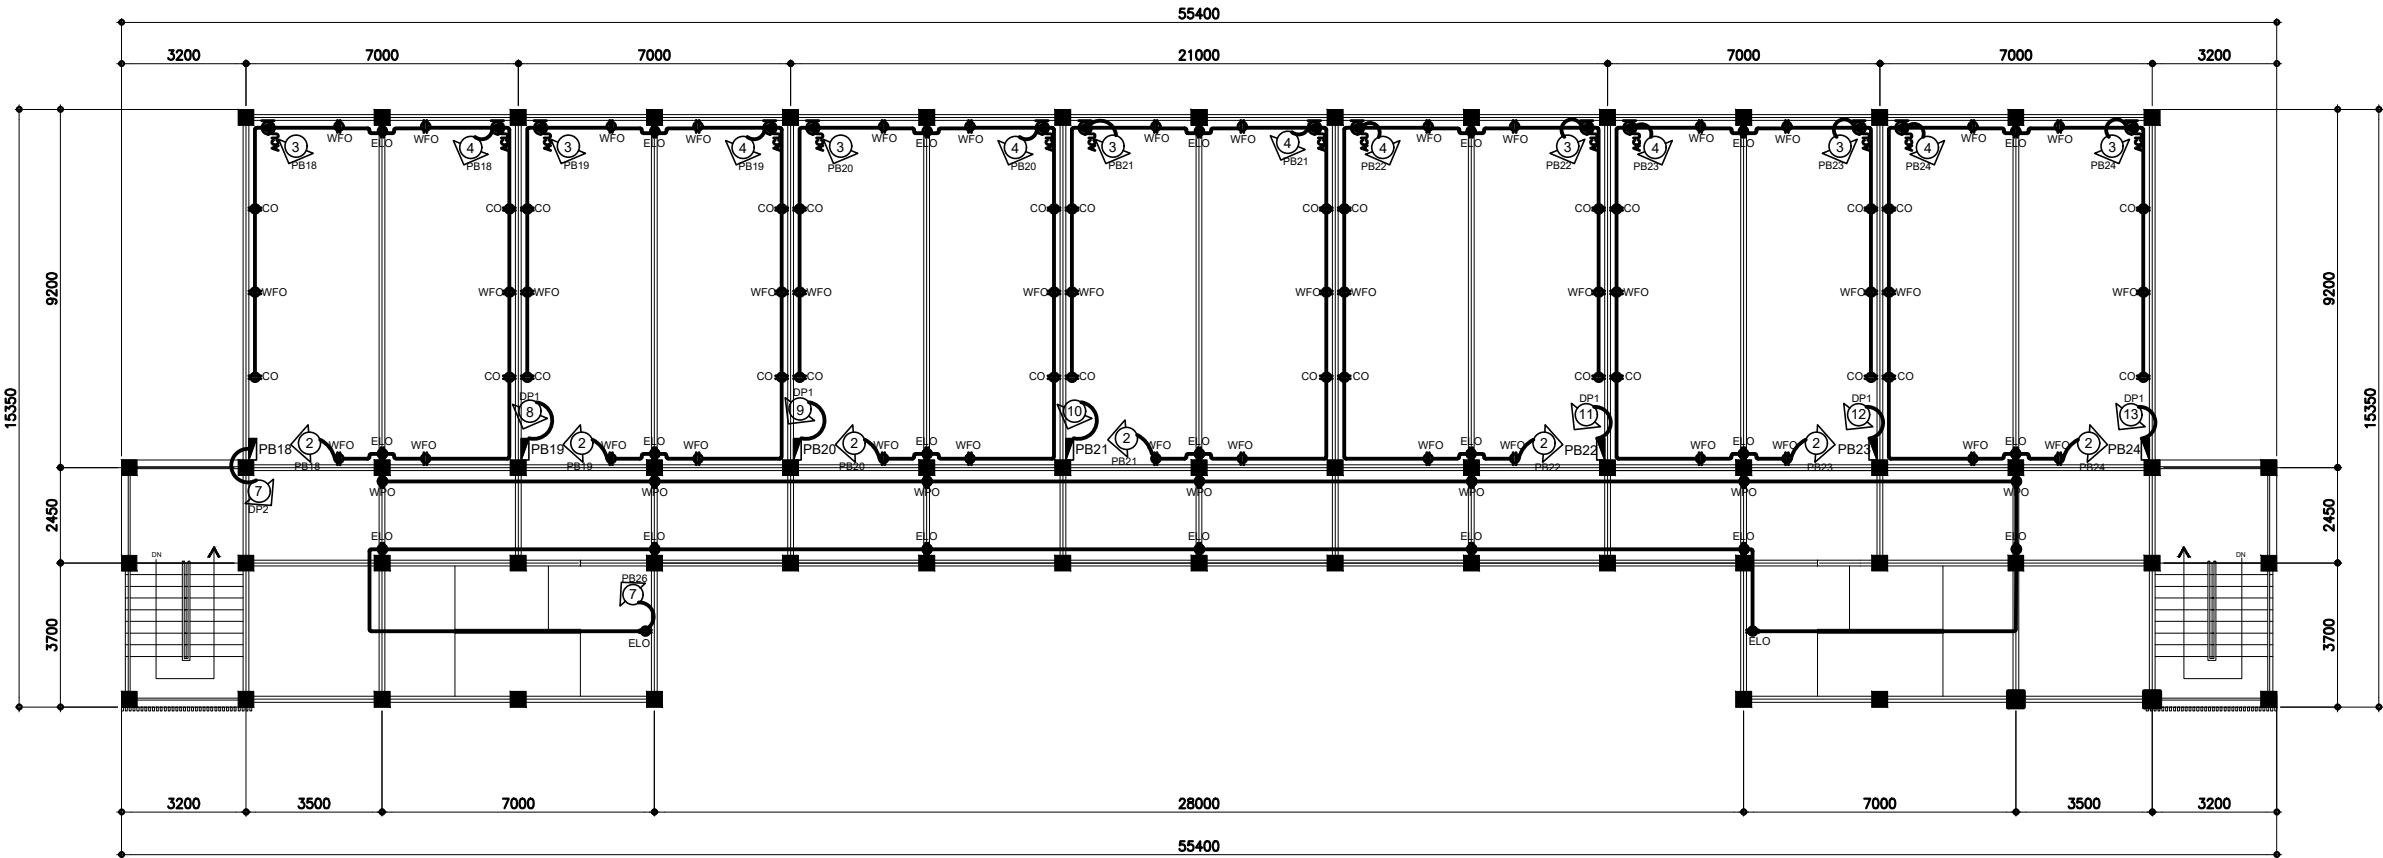

**FOURTH FLOOR
POWER LAYOUT**
SCALE : 1:150 MTS.



BATAAN PENINSULA STATE UNIVERSITY
TECHNICAL WORKING GROUP FOR INFRASTRUCTURE
CAPITOL COMPOUND, BRGY. TENEJERO, CITY OF BALANGA, BATAAN
E-MAIL: bpsu.twginfra2016@gmail.com / bpsuppes2017@gmail.com
TELEPHONE NO. : (047) 237-15-98

LEGEND			
S1a	TUMBLER SWITCH, SINGLE POLE	□	PINLIGHT WITH LED BULB
S2ab	TUMBLER SWITCH, 2-GANG	—	SINGLE T8 LED LIGHTS
S3abc	TUMBLER SWITCH, 3-GANG	□EF	EXHAUST FAN
S3W-ab...	TUMBLER SWITCH, 3-WAY	—	TRACK LIGHTS
CO	DUPLEX CONVENIENCE OUTLET	□	PINLIGHTS WITH LED BULB
WFO	WALL FAN MOUNTED C.O.	○	WALL LIGHT
ELO	EMERGENCY LIGHT OUTLET	●	LAMP POST
WPO	WEATHERPROOF C.O.	●	BOLLARD LIGHTS
ACU	AIRCONDITIONING UNIT OUTLET	■	PANEL BOARD
1	CIRCUIT HOMERUN		

PROJECT TITLE		
REPAIR & REHABILITATION OF ACADEMIC BLDG. II AT DINA- LUPIHAN CAMPUS		
LOCATION		
BATAAN PENINSULA STATE UNIVERSITY (DINALUPHAN CAMPUS) DINALUPHAN, BATAAN		
STRUCTURAL ENGINEER		
REP. NO.		
PTR. NO.		
PLATE		
TIN NO.		
MASTER PLUMBER/SANITARY ENGINEER		
REP. NO.		
PTR. NO.		
PLATE		
TIN NO.		
PROFESSIONAL ELECTRICAL ENGINEER		
REP. NO.		
PTR. NO.		
PLATE		
TIN NO.		
PROFESSIONAL MECHANICAL ENGINEER		
REP. NO.		
PTR. NO.		
PLATE		
TIN NO.		
REVISION		
NO.	DESCRIPTION	DATE
1		
2		
PREPARED BY:		
AR. ROXETTE S. UMEREZ		
ARCHITECT 1, BPSU TWG		
REP. NO.		
PTR. NO.		
PLATE		
TIN NO.		
REVIEWED BY:		
MR. BILLY ALIPIO		
CAMPUS DIRECTOR		
NOTED BY:		
ENGR. ALFREDO D. VALENTOS		
DIRECTOR OF PPES		
RECOMMENDED BY:		
DR. EDMUNDO C. TUNGOL		
VICE PRESIDENT ADMIN. & FINANCE		
APPROVED BY:		
DR. GREGORIO J. RODIS		
UNIVERSITY PRESIDENT		
REPUBLIC ACT 9266		
NOTE: THIS DRAWING, AS AN INSTRUMENT OF SERVICE IS THE PROPERTY OF : BATAAN PENINSULA STATE UNIVERSITY AND AS SUCH MUST NOT BE REPRODUCED OR COPIED IN PART OR IN WHOLE WITHOUT THEIR PERMISSION ALL DRAWINGS ARE TO BE RETURNED WHEN NO LONGER IN USE.		
SHEET CONTENT:		SHEET NUMBER
FOURTH FLOOR POWER LAYOUT LEGEND		E-DC-09