






A PERSPECTIVE
A-FDC-00 A-FDC-00 SCALE : NTS.

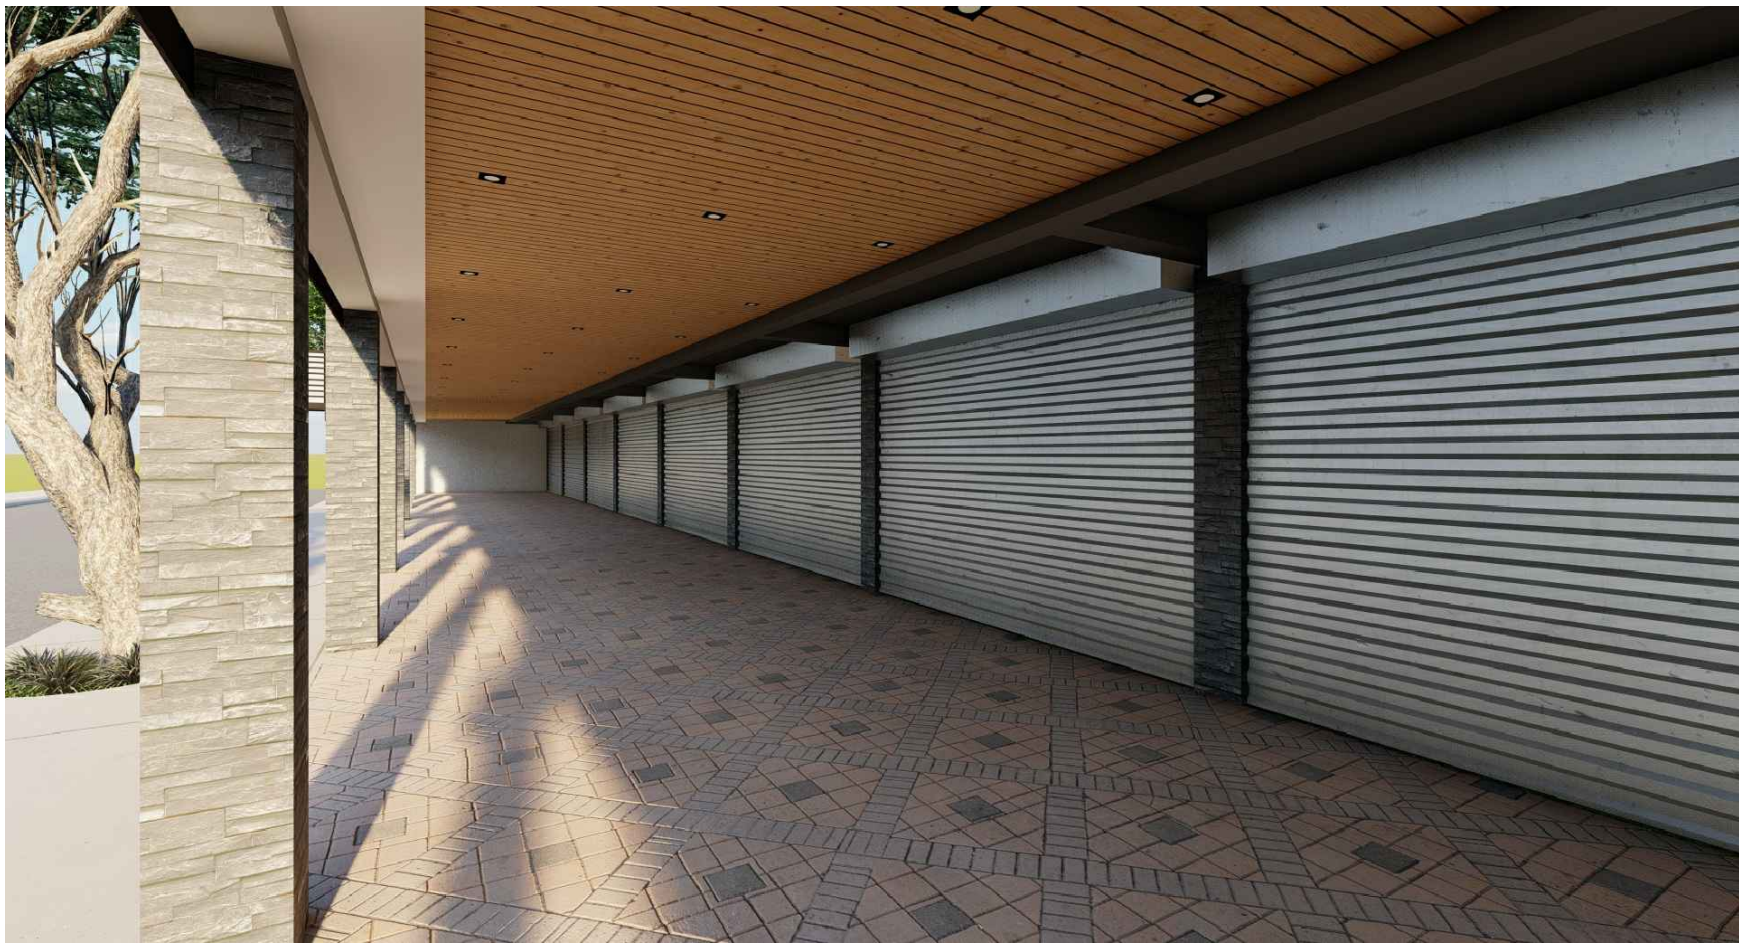

B PERSPECTIVE
A-FDC-00 A-FDC-00 SCALE : NTS.

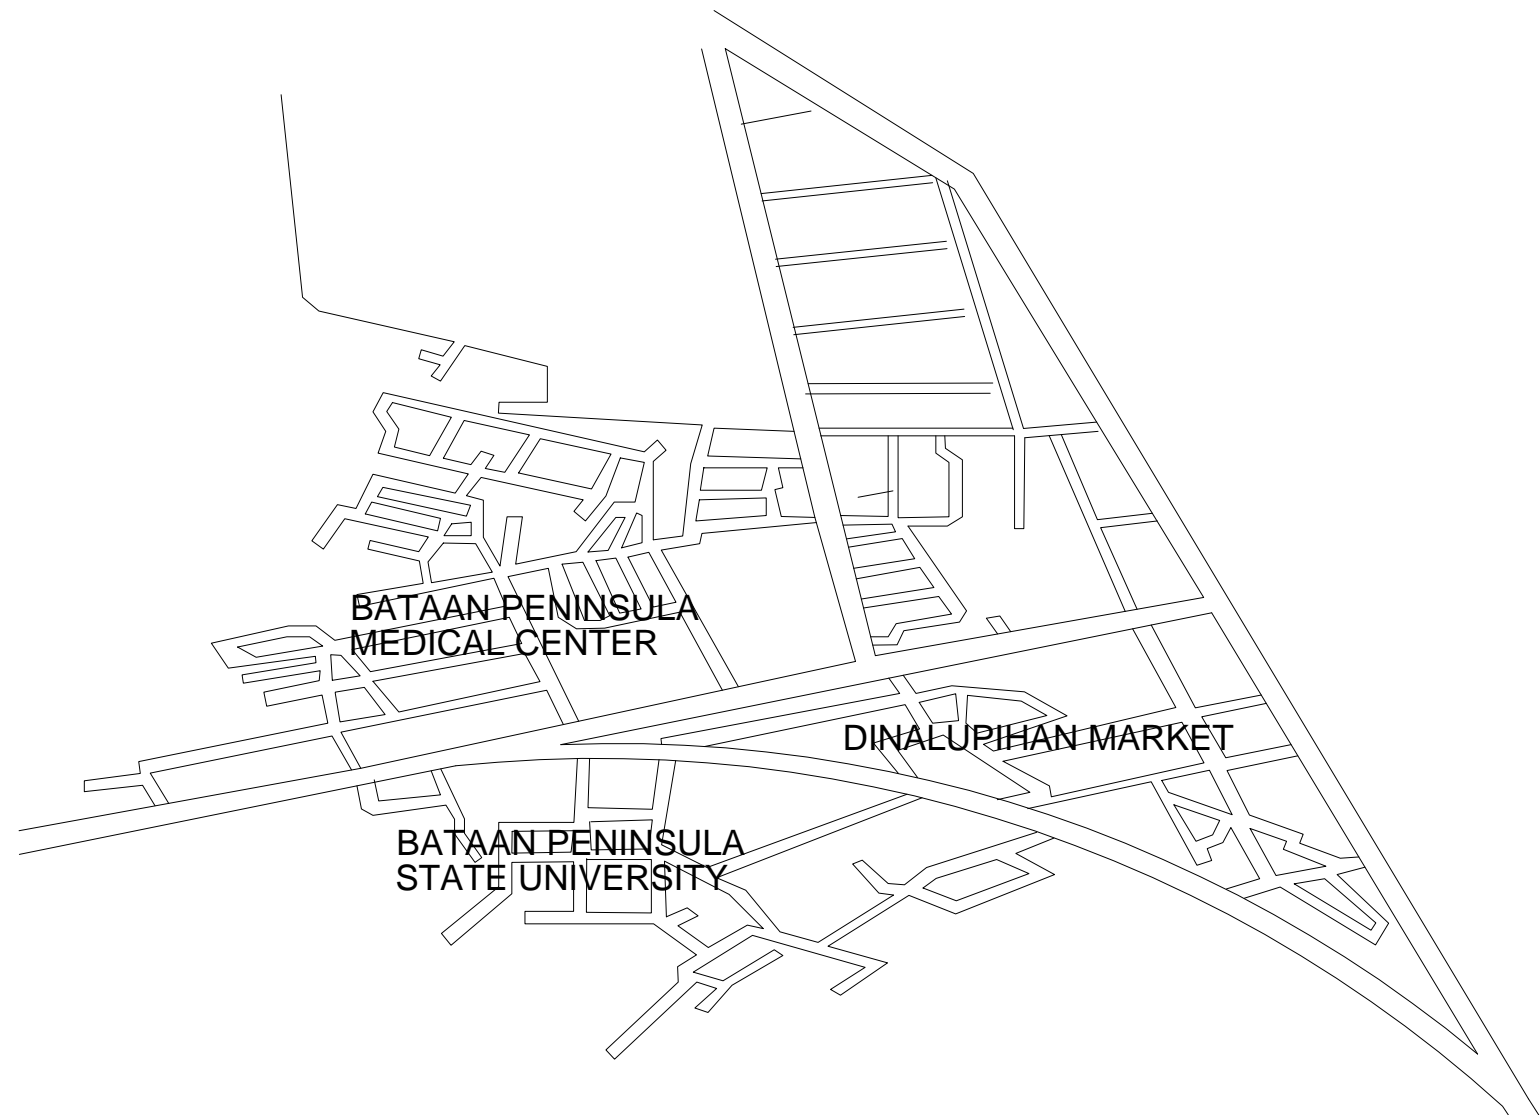


C VICINITY MAP
A-FDC-00 A-FDC-00 SCALE : NTS.

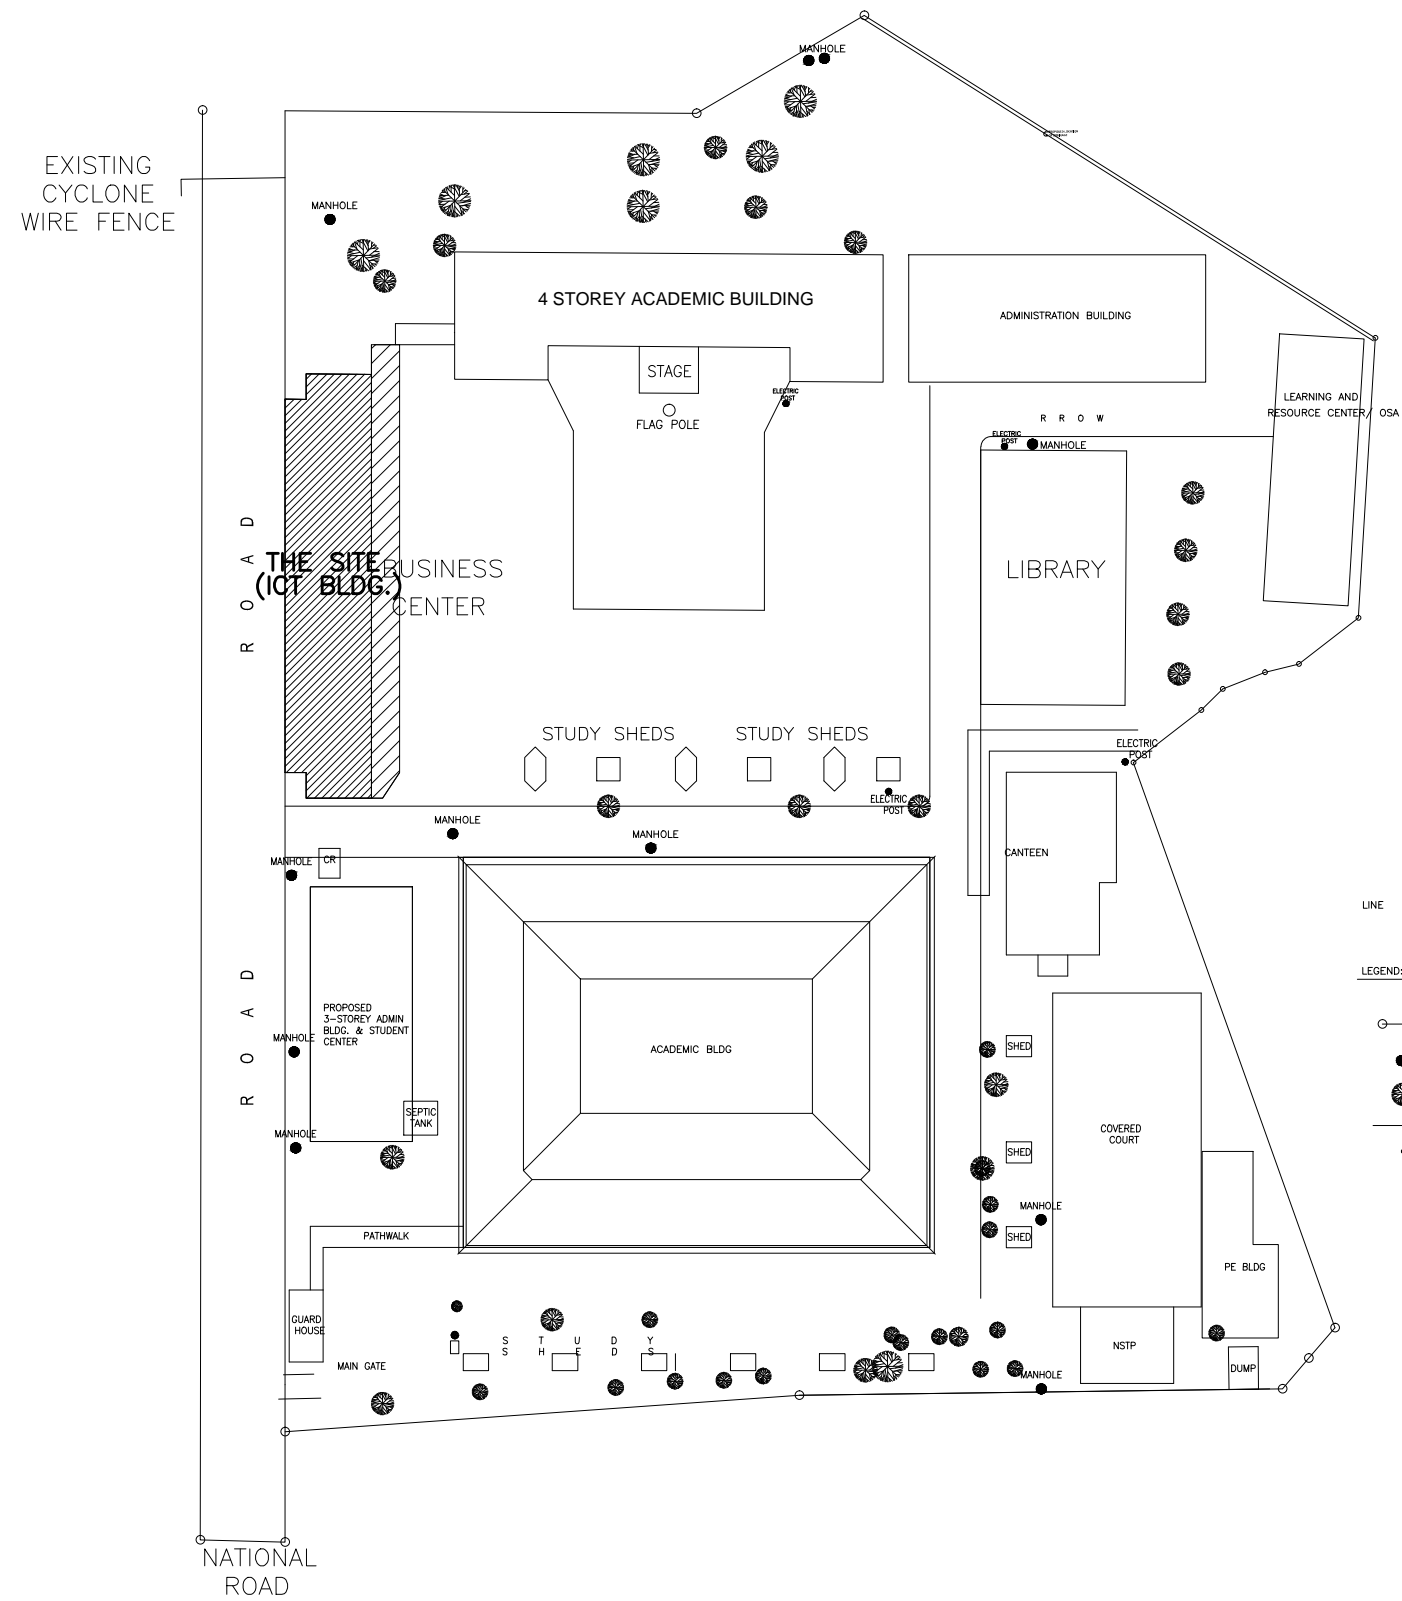

D SITE DEVELOPMENT PLAN
A-FDC-00 A-FDC-00 SCALE : NTS.

PROJECT TITLE		
PROPOSED FACADE IMPROVE- MENT OF BUSINESS CENTER & ICT BUILDING		
LOCATION:		
BATAAN PENINSULA STATE UNIVERSITY DINALUPIHAN CAMPUS, DINALUPIHAN, BATAAN		
STRUCTURAL ENGINEER		
REG. NO. :		
PTR. NO. :		
PLACE :		
TIN NO. :		
MASTER PLUMBER/SANITARY ENGINEER		
REG. NO. :		
PTR. NO. :		
PLACE :		
TIN NO. :		
PROFESSIONAL ELECTRICAL ENGINEER		
REG. NO. :		
PTR. NO. :		
PLACE :		
TIN NO. :		
PROFESSIONAL MECHANICAL ENGINEER		
REG. NO. :		
PTR. NO. :		
PLACE :		
TIN NO. :		
REVISION		
NO.	DESCRIPTION	DATE
1		
2		
PREPARED BY:		
AR. ROXETTE S. UMEREZ		
HEAD OF TECHNICAL WORKING GROUP		
REG. NO. :		
PTR. NO. :		
PLACE :		
TIN NO. :		
REVIEWED BY:		
MR. BILLY ALIPIO		
CAMPUS DIRECTOR		
NOTED BY:		
ENGR. ALFREDO D. VALENTOS		
DIRECTOR OF PPES		
RECOMMENDED BY:		
DR. EDMUNDO C. TUNGOL		
VICE PRESIDENT ADMIN. & FINANCE		
APPROVED BY:		
DR. GREGORIO J. RODIS		
UNIVERSITY PRESIDENT		
REPUBLIC ACT 9266.		
NOTE: THIS DRAWING, AS AN INSTRUMENT OF SERVICE IS THE PROPERTY OF : BATAAN PENINSULA STATE UNIVERSITY AND AS SUCH MUST NOT BE REPRODUCED OR COPIED IN PART OR IN WHOLE WITHOUT THEIR PERMISSION ALL DRAWINGS ARE TO BE RETURNED WHEN NO LONGER IN USE,		
SHEET CONTENT:		SHEET NUMBER:
PERSPECTIVE VICINITY MAP SITE DEVT. PLAN		A-FDC-00



BATAAN PENINSULA STATE UNIVERSITY
TECHNICAL WORKING GROUP FOR INFRASTRUCTURE

CAPITOL COMPOUND, Brgy. TENEJERO, CITY OF BALANGA, BATAAN,
E-MAIL: bpsu.teinfra2016@gmail.com/ bpsupes2017@gmail.com
TELEPHONE NO. : (047) 237-15-98

TABLE OF CONTENTS	
SHEET NUMBER	DESCRIPTION
A-FDC-00	WICINITY MAP, PERSPECTIVE, SITE DEVELOPMENT PLAN
A-FDC-01	GROUND FLOOR PLAN, FRONT ELEVATION
A-FDC-02	SECOND FLOOR PLAN, REFLECTED CEILING PLAN
S-FDC-01	FOUNDATION PLAN, ROOF FRAMING PLAN
S-FDC-02	FOUNDATION DETAILS, BEAM DETAILS, COLUMN DETAILS, TRUSS DETAILS
P-FDC-01	SANITARY LAYOUT, STORM DRAINAGE LAYOUT, SEPTIC TANK DETAIL CATCH BASIN DETAIL
E-FDC-01	LIGHTING LAYOUT, GENERAL NOTES, LEGENDS & SYMBOLS

NOTE :
WRITTEN DIMENSIONS ON THESE DRAWINGS SHALL HAVE PRECEDENCE OVER SCALED
DIMENSIONS. CONTRACTORS SHALL VERIFY AND BE RESPONSIBLE FOR ALL DIMENSIONS
AND CONDITIONS ON THE JOB. THE DESIGNER MUST BE NOTIFIED IMMEDIATELY OF ANY
VARIATIONS FROM THE DIMENSIONS AND CONDITIONS SHOWN BY THESE DRAWINGS.

NOTE :
IF IN DOUBT, ASK
DO NOT SCALE!

NOTE :
NOT A DISCREPANCY ON ALL DRAWINGS & SPECIFICATIONS
(ARCHITECTURAL, STRUCTURAL, SANITARY, ELECTRICAL,
MECHANICAL, ETC.) SHALL BE SUBJECT FOR VERIFICATION