

NOTE: DIMENSIONS ON THESE DRAWINGS SHALL HAVE PRECEDENCE OVER SCALED DIMENSIONS. CONTRACTORS SHALL VERIFY AND BE RESPONSIBLE FOR ALL DIMENSIONS AND CONDITIONS ON THE JOB. THE DESIGNER MUST BE NOTIFIED IMMEDIATELY OF ANY VARIATIONS FROM THE DIMENSIONS AND CONDITIONS SHOWN BY THESE DRAWINGS.



NOTE: DISCREPANCY ON ALL DRAWINGS & SPECIFICATIONS (ARCHITECTURAL, STRUCTURAL, SANITARY, ELECTRICAL, MECHANICAL ETC.) SHALL BE SUBJECT FOR VERIFICATION. DO NOT SCALE!



BATAAN PENINSULA STATE UNIVERSITY  
TECHNICAL WORKING GROUP FOR INFRASTRUCTURE

CAPITOL COMPOUND, BRGY. TENEJERO, CITY OF BALANGA, BATAAN,  
E-MAIL: bpsu.twginfo2016@gmail.com/ bpsupes2017@gmail.com  
TELEPHONE NO. : (047) 237-15-98

| LEGEND | DESCRIPTION                  |  |
|--------|------------------------------|--|
| FACP   | FIRE ALARM AND CONTROL PANEL |  |
| SD     | SMOKE DETECTOR               |  |
| BELL   | FIRE ALARM BELL              |  |
| PS     | PULL STATION                 |  |
|        |                              |  |

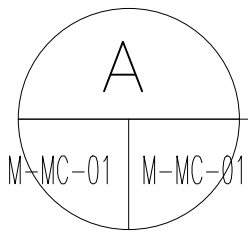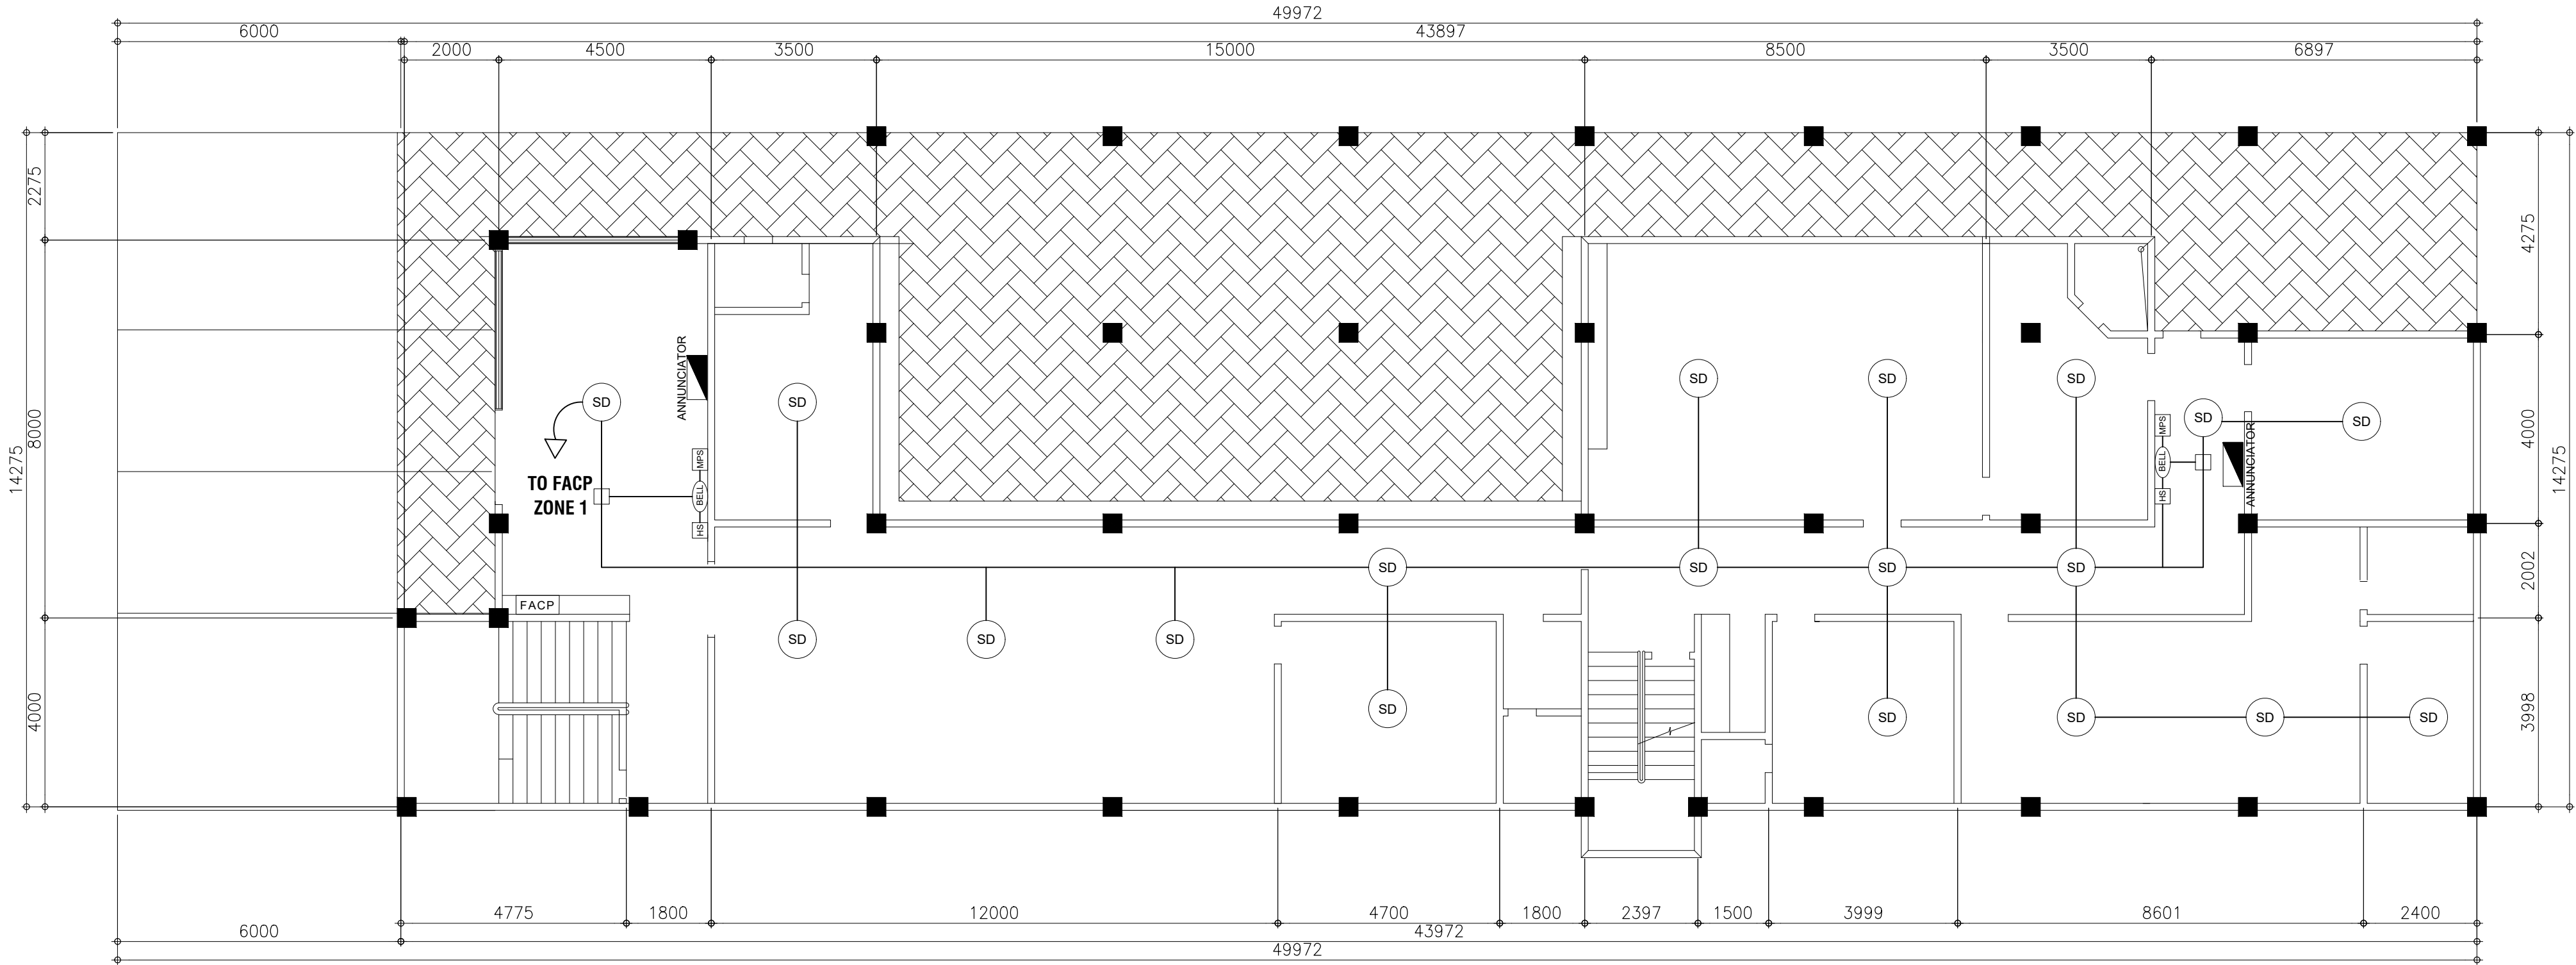

GROUND FLOOR PLAN  
SMOKE DETECTOR LAYOUT PLAN

SCALE : 1:100 MTS.

PROJECT TITLE:  
  
**PROPOSED ADMIN BUILDING  
AT MAIN CAMPUS**

LOCATION:  
BATAAN PENINSULA STATE UNIVERSITY (MAIN CAMPUS)  
CAPITOL COMPOUND, CITY OF BALANGA, BATAAN

STRUCTURAL ENGINEER  
REG. NO. :  
PTR. NO. :  
PLACE :  
TIN NO. :

MASTER PLUMBER/SANITARY ENGINEER  
REG. NO. :  
PTR. NO. :  
PLACE :  
TIN NO. :

PROFESSIONAL ELECTRICAL ENGINEER  
REG. NO. :  
PTR. NO. :  
PLACE :  
TIN NO. :

REVISION  
NO. DESCRIPTION DATE

CERTIFIED BY:  
  
**ENGR. ALFREDO D. VALENTOS**  
PROFESSIONAL MECHANICAL ENGINEER  
REG. NO. :  
PTR. NO. :  
PLACE :  
TIN NO. :  
APPROVED BY:  
  
**DR. GREGORIO J. RODIS**  
UNIVERSITY PRESIDENT

REPUBLIC ACT 9266.  
NOTE: THIS DRAWING, AS AN INSTRUMENT  
OF SERVICE IS THE PROPERTY OF :  
BATAAN PENINSULA STATE UNIVERSITY  
AND AS SUCH MUST NOT BE REPRODUCED  
OR COPIED IN PART OR IN WHOLE  
WITHOUT THEIR PERMISSION ALL  
DRAWINGS ARE TO BE RETURNED WHEN  
NO LONGER IN USE.

SHEET CONTENT:  
• SMOKE DETECTOR  
LAYOUT PLAN  
- GROUND FLOOR PLAN

SHEET NUMBER:  
  
**M-01**

NOTE: DIMENSIONS ON THESE DRAWINGS SHALL HAVE PRECEDENCE OVER SCALED DIMENSIONS. CONTRACTORS SHALL VERIFY AND BE RESPONSIBLE FOR ALL DIMENSIONS AND CONDITIONS ON THE JOB. THE DESIGNER MUST BE NOTIFIED IMMEDIATELY OF ANY VARIATIONS FROM THE DIMENSIONS AND CONDITIONS SHOWN BY THESE DRAWINGS.



NOTE: DISCREPANCY ON ALL DRAWINGS & SPECIFICATIONS (ARCHITECTURAL, STRUCTURAL, SANITARY, ELECTRICAL, MECHANICAL ETC.) SHALL BE SUBJECT FOR VERIFICATION. INQUIRY: ASK! DO NOT SCALE!



BATAAN PENINSULA STATE UNIVERSITY  
TECHNICAL WORKING GROUP FOR INFRASTRUCTURE

CAPITOL COMPOUND, BRGY. TENEJERO, CITY OF BALANGA, BATAAN,  
E-MAIL: bpsu.twginfo2016@gmail.com/ bpsupes2017@gmail.com  
TELEPHONE NO. : (047) 237-15-98

| LEGEND | DESCRIPTION                  |  |
|--------|------------------------------|--|
| FACP   | FIRE ALARM AND CONTROL PANEL |  |
| SD     | SMOKE DETECTOR               |  |
| BELL   | FIRE ALARM BELL              |  |
| PS     | PULL STATION                 |  |
|        |                              |  |

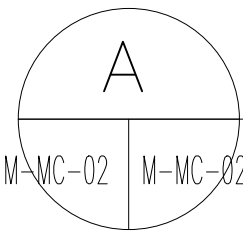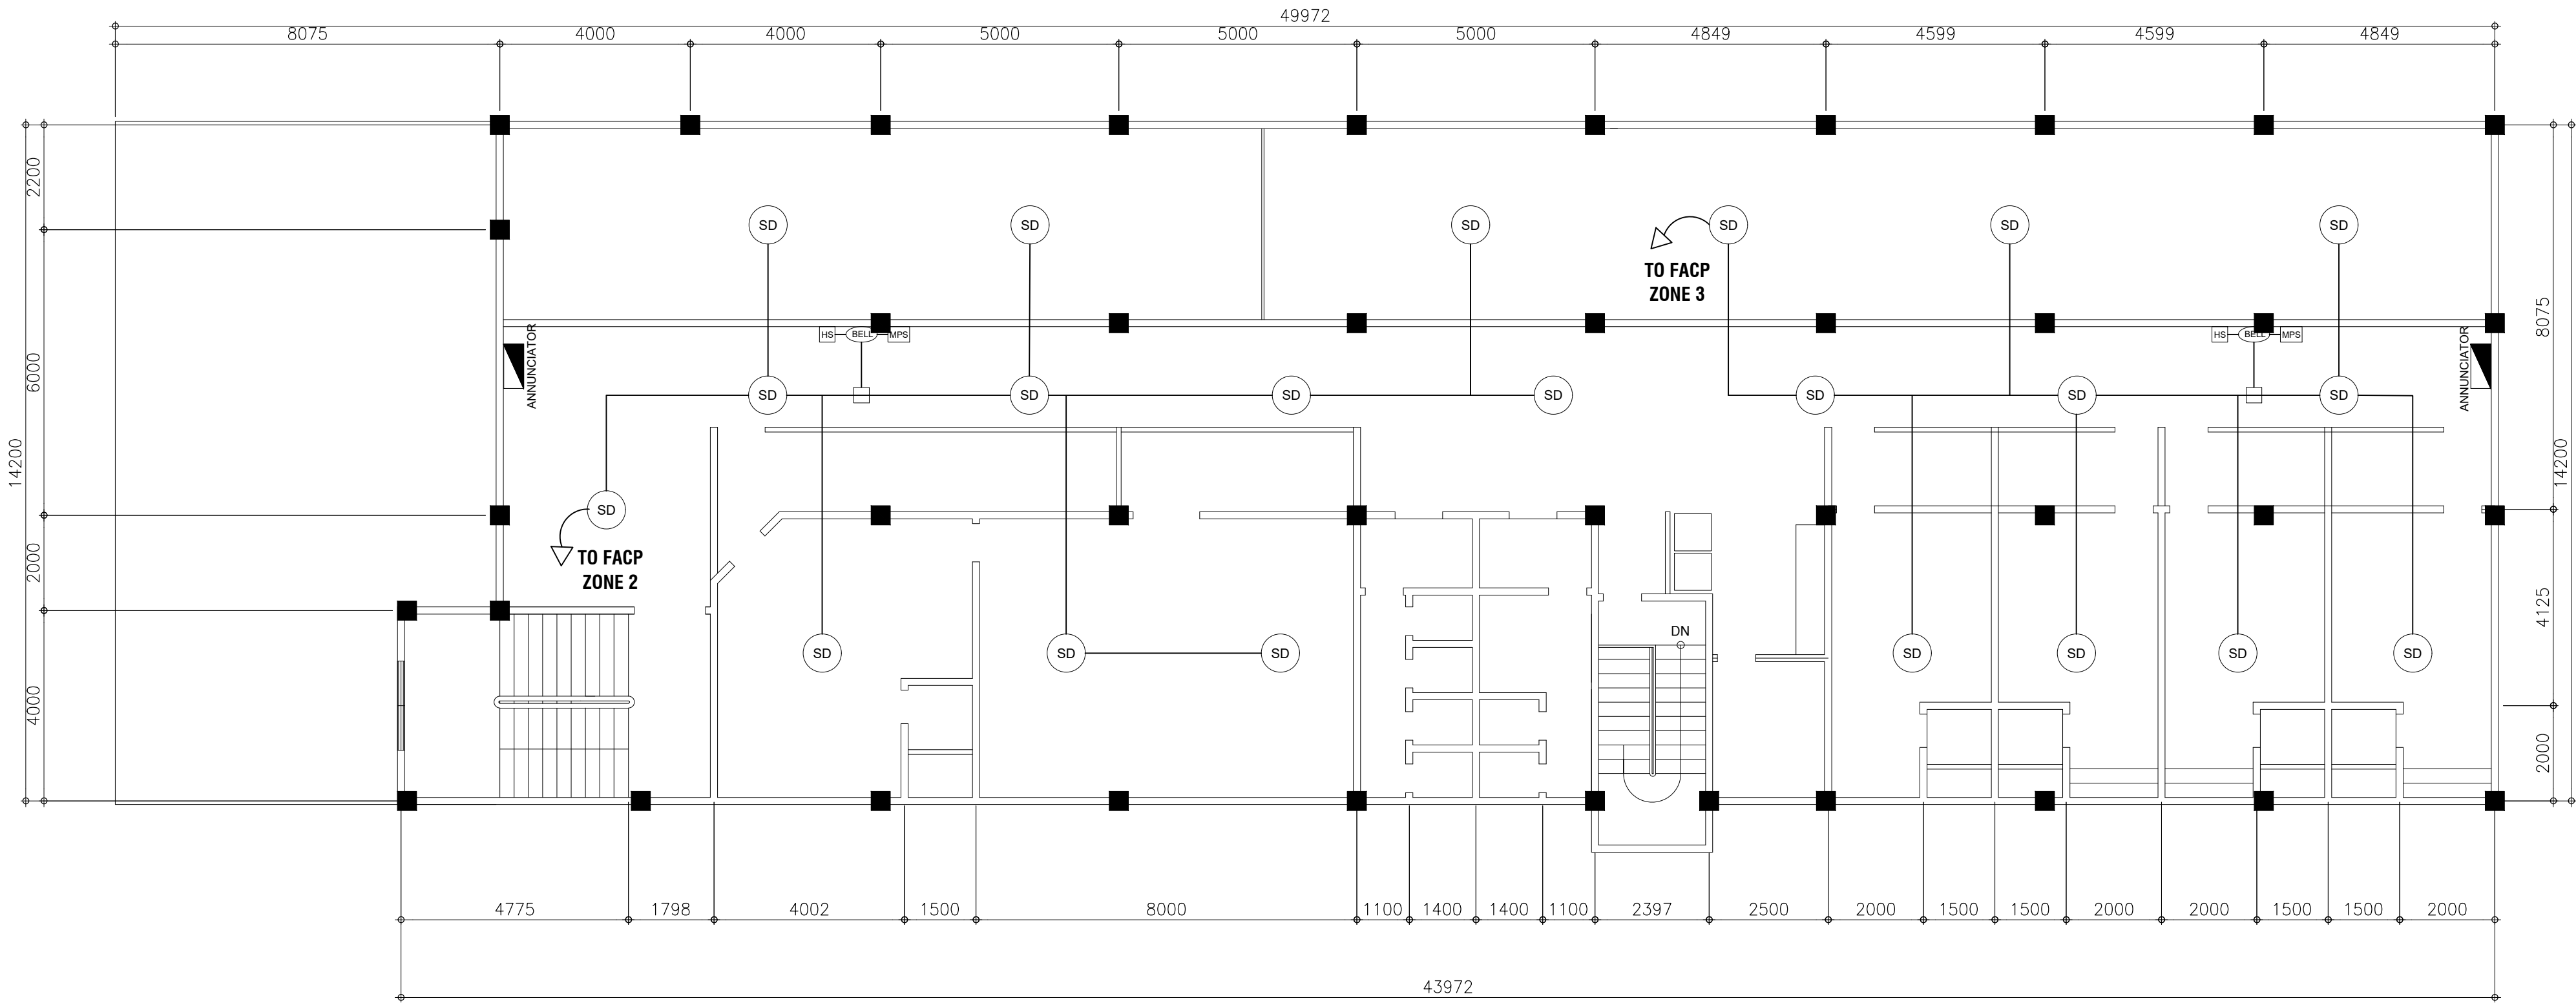

SECOND FLOOR PLAN  
SMOKE DETECTOR LAYOUT PLAN

SCALE : 1:100 MTS.

PROJECT TITLE:  
  
PROPOSED ADMIN BUILDING  
AT MAIN CAMPUS

LOCATION:  
BATAAN PENINSULA STATE UNIVERSITY (MAIN CAMPUS)  
CAPITOL COMPOUND, CITY OF BALANGA, BATAAN

STRUCTURAL ENGINEER  
REG. NO. :  
PTR. NO. :  
PLACE :  
TIN NO. :

MASTER PLUMBER/SANITARY ENGINEER  
REG. NO. :  
PTR. NO. :  
PLACE :  
TIN NO. :

PROFESSIONAL ELECTRICAL ENGINEER  
REG. NO. :  
PTR. NO. :  
PLACE :  
TIN NO. :

REVISION  
NO. DESCRIPTION DATE

CERTIFIED BY:  
  
ENGR. ALFREDO D. VALENTOS  
PROFESSIONAL MECHANICAL ENGINEER  
REG. NO. :  
PTR. NO. :  
PLACE :  
TIN NO. :  
APPROVED BY:  
  
DR. GREGORIO J. RODIS  
UNIVERSITY PRESIDENT

REPUBLIC ACT 9266.  
  
NOTE: THIS DRAWING, AS AN INSTRUMENT  
OF SERVICE IS THE PROPERTY OF :  
BATAAN PENINSULA STATE UNIVERSITY  
AND AS SUCH MUST NOT BE REPRODUCED  
OR COPIED IN PART OR IN WHOLE  
WITHOUT THEIR PERMISSION ALL  
DRAWINGS ARE TO BE RETURNED WHEN  
NO LONGER IN USE.

SHEET CONTENT:  
• SMOKE DETECTOR  
LAYOUT PLAN  
- SECOND FLOOR PLAN

SHEET NUMBER:  
  
M-02



NOTE: ALL DIMENSIONS ON THESE DRAWINGS SHALL HAVE PRECEDENCE OVER SCALED DIMENSIONS. CONTRACTORS SHALL VERIFY AND BE RESPONSIBLE FOR ALL DIMENSIONS AND CONDITIONS ON THE JOB. THE DESIGNER MUST BE NOTIFIED IMMEDIATELY OF ANY VARIATIONS FROM THE DIMENSIONS AND CONDITIONS SHOWN BY THESE DRAWINGS.



NOTE: DISCREPANCY ON ALL DRAWINGS & SPECIFICATIONS (ARCHITECTURAL, STRUCTURAL, SANITARY, ELECTRICAL, MECHANICAL ETC.) SHALL BE SUBJECT FOR VERIFICATION. DO NOT SCALE!



BATAAN PENINSULA STATE UNIVERSITY  
TECHNICAL WORKING GROUP FOR INFRASTRUCTURE

CAPITOL COMPOUND, BRGY. TENEJERO, CITY OF BALANGA, BATAAN,  
E-MAIL: bpsu.twginfo2016@gmail.com/ bpsupes2017@gmail.com  
TELEPHONE NO. : (047) 237-15-98

| LEGEND | DESCRIPTION                  |  |
|--------|------------------------------|--|
| FACP   | FIRE ALARM AND CONTROL PANEL |  |
| SD     | SMOKE DETECTOR               |  |
| BELL   | FIRE ALARM BELL              |  |
| PS     | PULL STATION                 |  |
|        |                              |  |

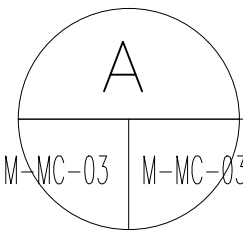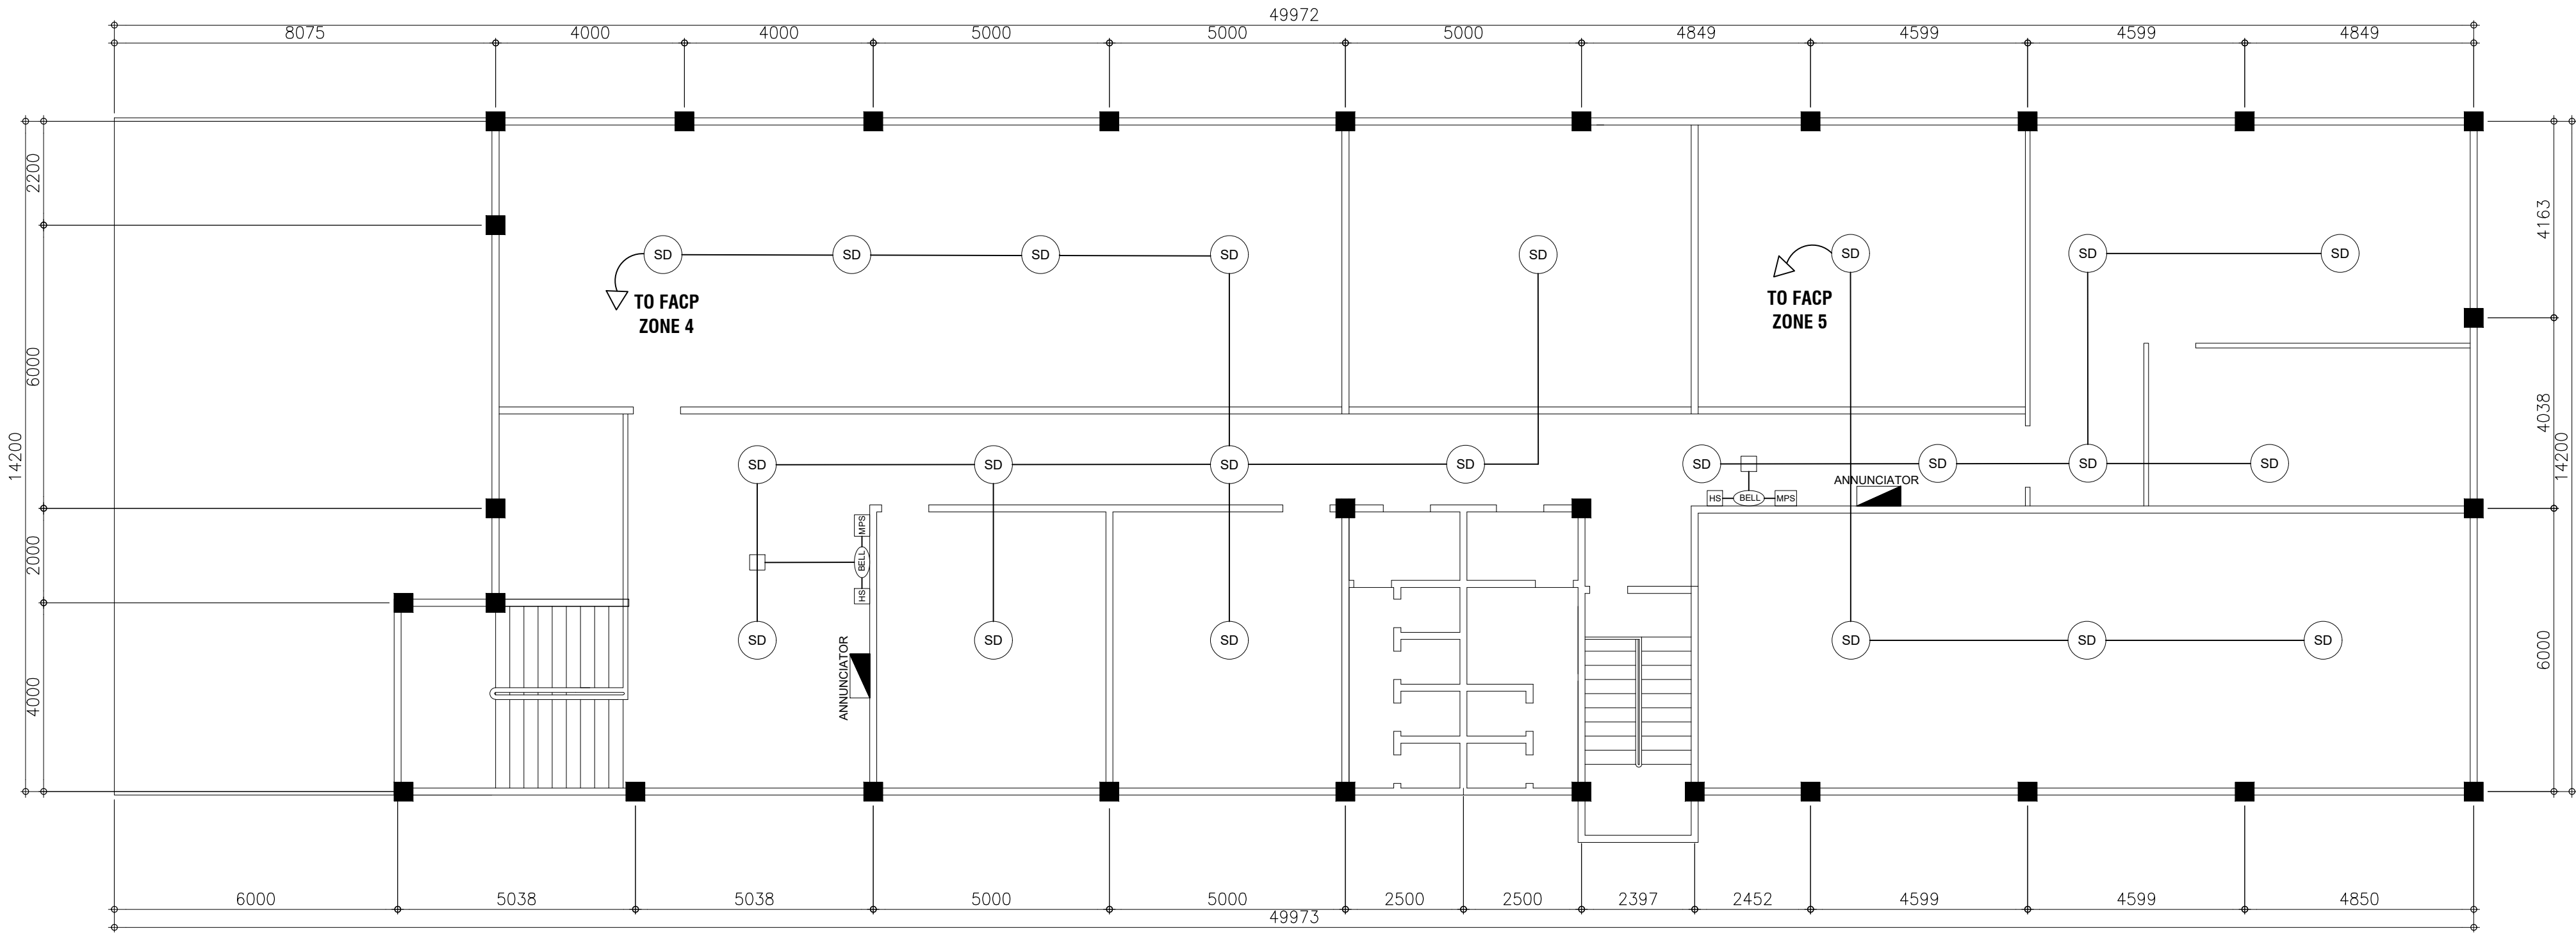

THIRD FLOOR PLAN  
SMOKE DETECTOR LAYOUT PLAN

SCALE : 1:100 MTS.

PROJECT TITLE:

PROPOSED ADMIN BUILDING  
AT MAIN CAMPUS

LOCATION:

BATAAN PENINSULA STATE UNIVERSITY (MAIN CAMPUS)  
CAPITOL COMPOUND, CITY OF BALANGA, BATAAN

STRUCTURAL ENGINEER

REG. NO. :  
PTR. NO. :  
PLACE :  
TIN NO. :

MASTER PLUMBER/SANITARY ENGINEER

REG. NO. :  
PTR. NO. :  
PLACE :  
TIN NO. :

PROFESSIONAL ELECTRICAL ENGINEER

REG. NO. :  
PTR. NO. :  
PLACE :  
TIN NO. :

REVISION

NO. DESCRIPTION DATE

CERTIFIED BY:

ENGR. ALFREDO D. VALENTOS  
PROFESSIONAL MECHANICAL ENGINEER

REG. NO. :  
PTR. NO. :  
PLACE :  
TIN NO. :

APPROVED BY:

DR. GREGORIO J. RODIS  
UNIVERSITY PRESIDENT

REPUBLIC ACT 9266.

NOTE: THIS DRAWING, AS AN INSTRUMENT  
OF SERVICE IS THE PROPERTY OF :  
BATAAN PENINSULA STATE UNIVERSITY  
AND AS SUCH MUST NOT BE REPRODUCED  
OR COPIED IN PART OR IN WHOLE  
WITHOUT THEIR PERMISSION ALL  
DRAWINGS ARE TO BE RETURNED WHEN  
NO LONGER IN USE.

SHEET CONTENT:

• SMOKE DETECTOR  
LAYOUT PLAN  
- THIRD FLOOR PLAN

SHEET NUMBER:

M-03



NOTE: ALL DIMENSIONS ON THESE DRAWINGS SHALL HAVE PRECEDENCE OVER SCALED DIMENSIONS. CONTRACTORS SHALL VERIFY AND BE RESPONSIBLE FOR ALL DIMENSIONS AND CONDITIONS ON THE JOB. THE DESIGNER MUST BE NOTIFIED IMMEDIATELY OF ANY VARIATIONS FROM THE DIMENSIONS AND CONDITIONS SHOWN BY THESE DRAWINGS.


NOTE: DISCREPANCY ON ALL DRAWINGS & SPECIFICATIONS (ARCHITECTURAL, STRUCTURAL, SANITARY, ELECTRICAL, MECHANICAL ETC.) SHALL BE SUBJECT FOR VERIFICATION. DO NOT SCALE!




BATAAN PENINSULA STATE UNIVERSITY  
TECHNICAL WORKING GROUP FOR INFRASTRUCTURE

CAPITOL COMPOUND, BRGY. TENEJERO, CITY OF BALANGA, BATAAN,  
E-MAIL: bpsu.twginfo2016@gmail.com/ bpsupes2017@gmail.com  
TELEPHONE NO. : (047) 237-15-98


| LEGEND | DESCRIPTION                  |  |
|--------|------------------------------|--|
| FACP   | FIRE ALARM AND CONTROL PANEL |  |
| SD     | SMOKE DETECTOR               |  |
| BELL   | FIRE ALARM BELL              |  |
| PS     | PULL STATION                 |  |

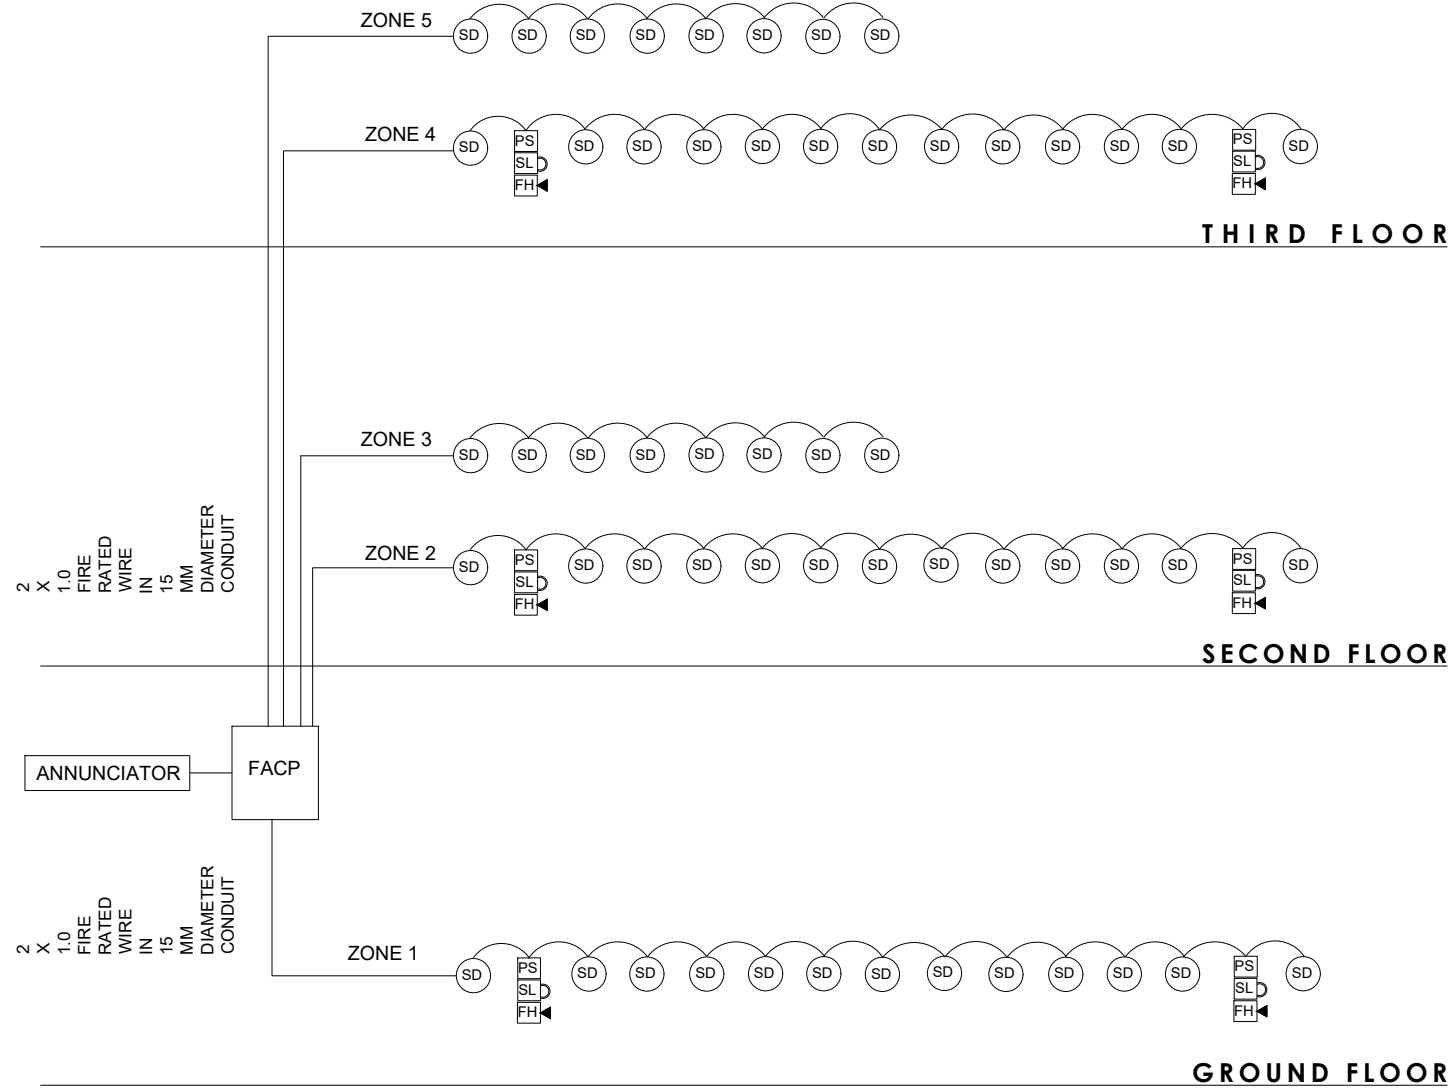


A ALARM MOTOR GANG DETAIL  
M-MC-04 M-MC-04 SCALE : NTS.

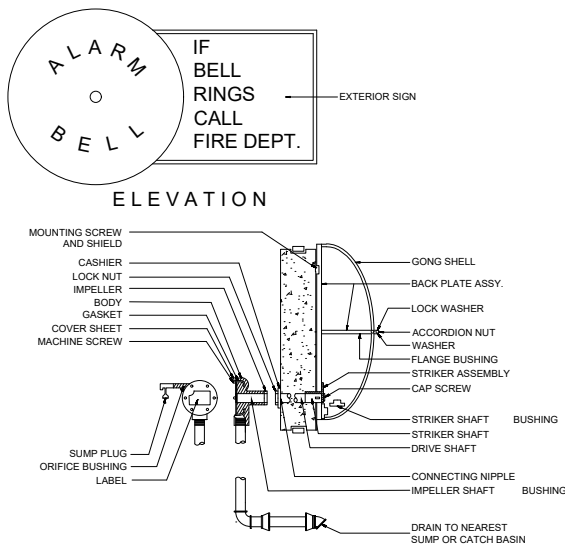


B MANUAL CALL POINT DETAIL  
M-MC-04 M-MC-04 SCALE : NTS.

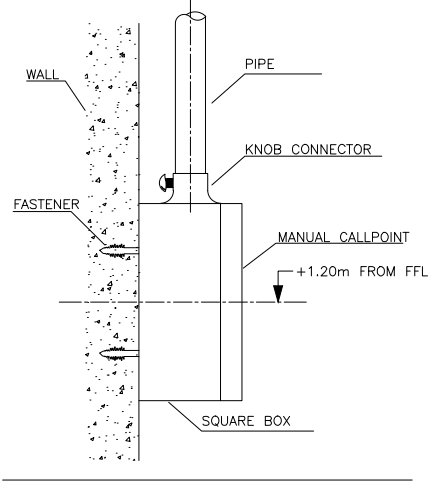

C EMBEDDED MANUAL CALL POINT DETAIL  
M-MC-04 M-MC-04 SCALE : NTS.

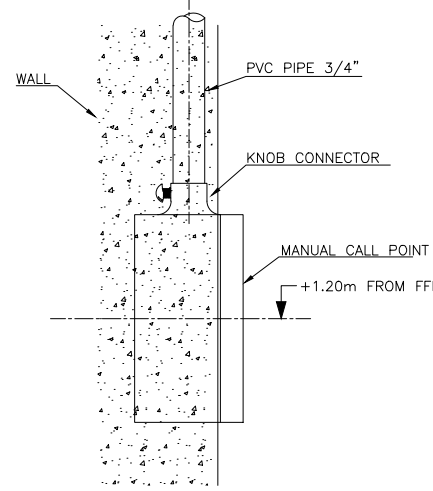

E SMOKE DETECTOR DETAIL  
M-MC-04 M-MC-04 SCALE : NTS.

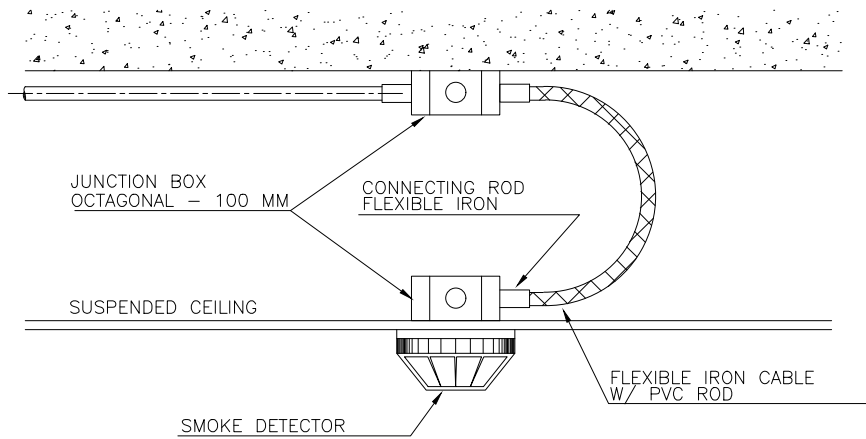

PROJECT TITLE:

PROPOSED ADMIN BUILDING  
AT MAIN CAMPUS

LOCATION:

BATAAN PENINSULA STATE UNIVERSITY (MAIN CAMPUS)  
CAPITOL COMPOUND, CITY OF BALANGA, BATAAN

STRUCTURAL ENGINEER

|            |  |
|------------|--|
| REG. NO. : |  |
| PTR. NO. : |  |
| PLACE :    |  |
| TIN NO. :  |  |

MASTER PLUMBER/SANITARY ENGINEER

|            |  |
|------------|--|
| REG. NO. : |  |
| PTR. NO. : |  |
| PLACE :    |  |
| TIN NO. :  |  |

PROFESSIONAL ELECTRICAL ENGINEER

|            |  |
|------------|--|
| REG. NO. : |  |
| PTR. NO. : |  |
| PLACE :    |  |
| TIN NO. :  |  |

REVISION

| NO. | DESCRIPTION | DATE |
|-----|-------------|------|
|     |             |      |
|     |             |      |

CERTIFIED BY:

ENGR. ALFREDO D. VALENTOS

PROFESSIONAL MECHANICAL ENGINEER

|            |  |
|------------|--|
| REG. NO. : |  |
| PTR. NO. : |  |
| PLACE :    |  |

APPROVED BY:

DR. GREGORIO J. RODIS

UNIVERSITY PRESIDENT

REPUBLIC ACT 9266.

NOTE: THIS DRAWING, AS AN INSTRUMENT  
OF SERVICE IS THE PROPERTY OF :  
BATAAN PENINSULA STATE UNIVERSITY  
AND AS SUCH MUST NOT BE REPRODUCED  
OR COPIED IN PART OR IN WHOLE  
WITHOUT THEIR PERMISSION ALL  
DRAWINGS ARE TO BE RETURNED WHEN  
NO LONGER IN USE.

|                |               |
|----------------|---------------|
| SHEET CONTENT: | SHEET NUMBER: |
| •DETAILS       | M-04          |