


16 MM dia. RSB (0.60m spaced @ 600mm O.C) and @ every concrete pouring termination


150 MM THICK PCCP (3,500 psi) with $\frac{1}{3}$ of Thickness transverse contraction joint @ every 4.50 meters

100 MM THICK BASE COURSE (min. 100% COMPACTION)

150 MM THICK SUB GRADE PREPARATION (98% COMPACTION)

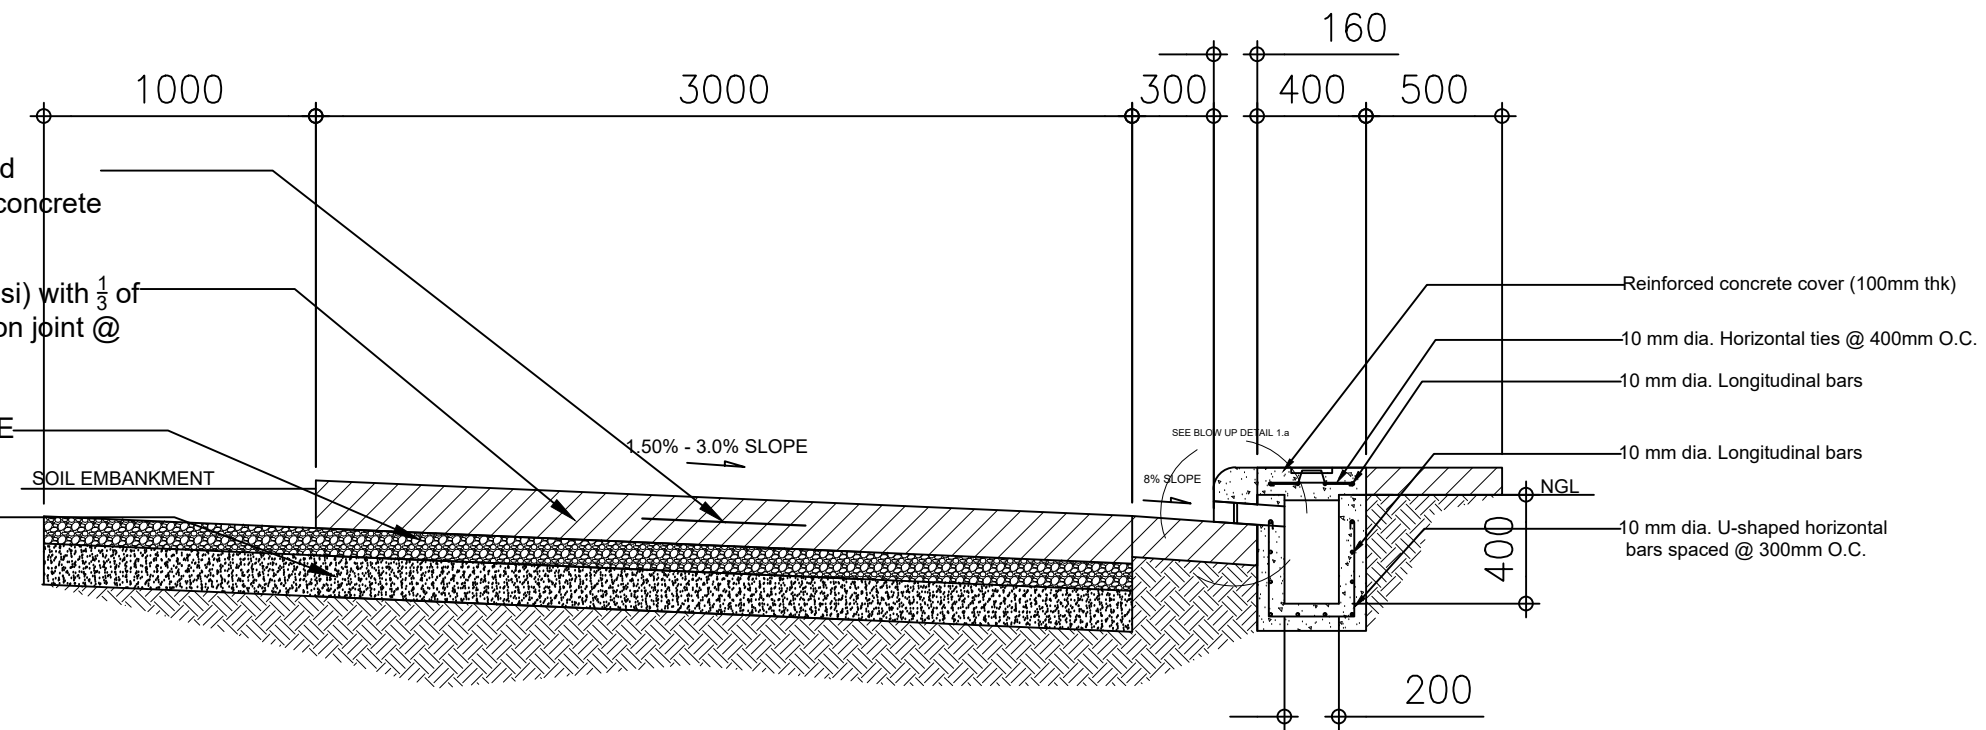


(3.00 meter WIDE ROAD)
CROSS SECTION DETAIL
SCALE : 1:15 MTS

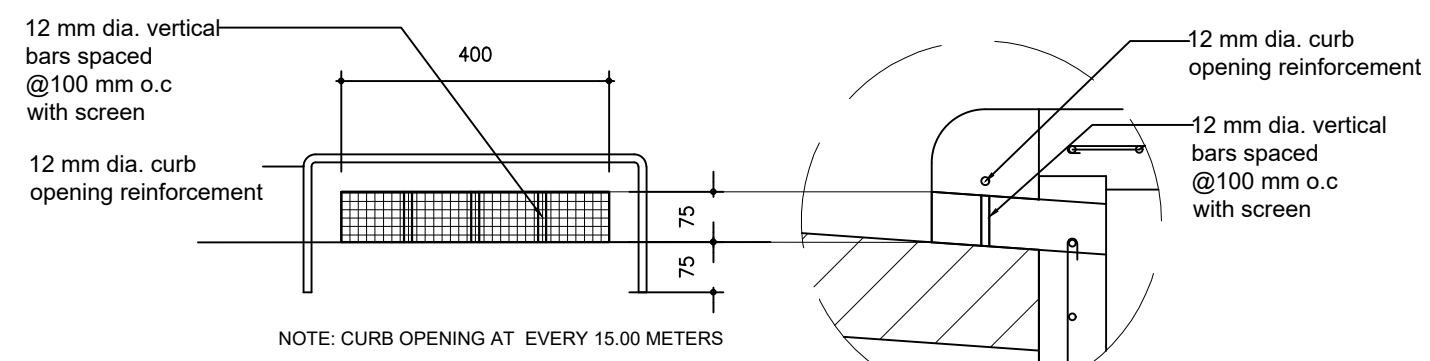

(CURB OPENING)
BLOW -UP DETAIL 1.a
SCALE : NTS

SITE PLAN:

TOTAL ROAD LENGTH: 301.00 lm
TOTAL CANAL LENGTH: 321.00 lm

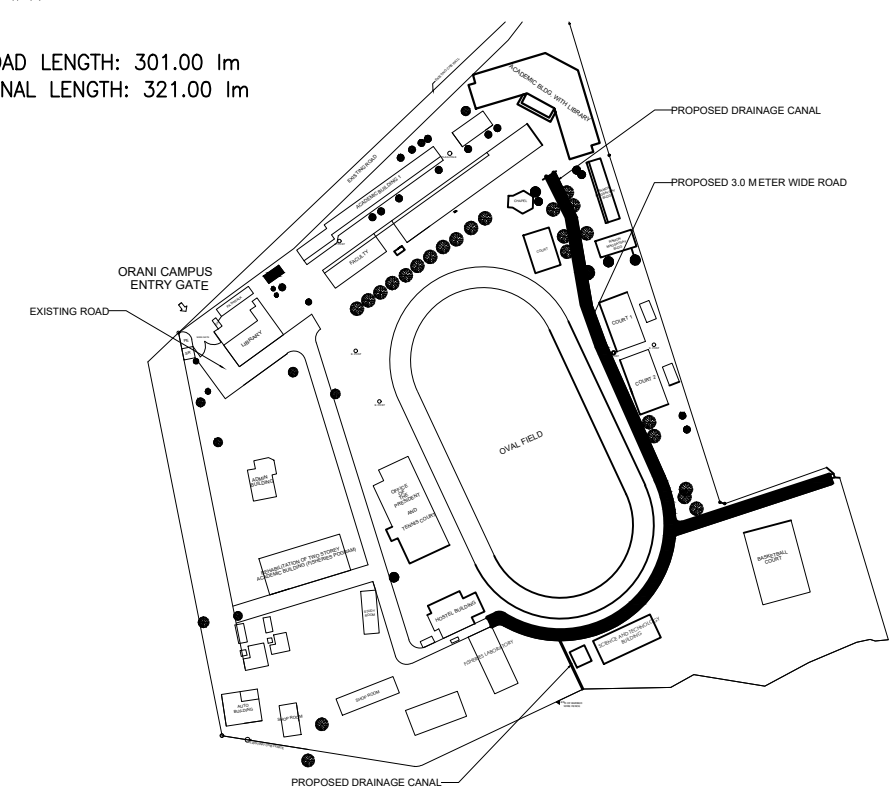



BATAAN PENINSULA STATE UNIVERSITY
TECHNICAL WORKING GROUP FOR INFRASTRUCTURE

CAPITOL COMPOUND, BRGY. TENJERO, CITY OF BALANGA, BATAAN,
E-MAIL: bpsu.tugtra2010@gmail.com/ bpsupes2017@gmail.com
TELEPHONE NO. : (047) 337-15-98

PROJECT TITLE
COMPLETION OF ROAD NETWORK AND IMPROVEMENT OF DRAINAGE SYSTEM IN THE MAIN COMPOUND AND CONSTRUCTION OF DRAINAGE IN ANNEX AT ORANI CAMPUS

LOCATION:
BATAAN PENINSULA STATE UNIVERSITY, ORANI CAMPUS

STRUCTURAL ENGINEER
REG. NO. :
P.R. NO. :
PLACE :
TH. NO. :

MASTER PLUMBER/SANITARY ENGINEER
REG. NO. :
P.R. NO. :
PLACE :
TH. NO. :

PROFESSIONAL ELECTRICAL ENGINEER
REG. NO. :
P.R. NO. :
PLACE :
TH. NO. :

PROFESSIONAL MECHANICAL ENGINEER
REG. NO. :
P.R. NO. :
PLACE :
TH. NO. :

REVISION		
NO.	DESCRIPTION	DATE
2		

PREPARED BY:
AR. ROXETTE S. UMEREZ
ARCHITECT 1, BPSU TWG

CHECKED BY:
AR. JO-ANA Z. TANEGA
ARCHITECT 1, PPES OFFICE

NOTED BY:
ENGR. ALFREDO D. VALENTOS
PPES DIRECTOR

RECOMMENDED BY:
DR. EDMUNDO C. TUNGOL
VICE PRESIDENT ADMIN. & FINANCE

APPROVED BY:
DR. GREGORIO J. RODIS
UNIVERSITY PRESIDENT

REPUBLIC ACT 9266.
NOTE: THIS DRAWING, AS AN INSTRUMENT OF SERVICE IS THE PROPERTY OF : BATAAN PENINSULA STATE UNIVERSITY AND AS SUCH MUST NOT BE REPRODUCED OR COPIED IN PART OR IN WHOLE WITHOUT THEIR PERMISSION ALL DRAWINGS ARE TO BE RETURNED WHEN NO LONGER IN USE.

SHEET CONTENT	SHEET NUMBER
CROSS SECTION DETAIL BLOW UP DETAIL 1.a	S3