


NOTE: ALL DIMENSIONS ON THESE DRAWINGS SHALL HAVE PRECEDENCE OVER SCALED DIMENSIONS. CONTRACTORS SHALL VERIFY AND BE RESPONSIBLE FOR ALL DIMENSIONS AND CONDITIONS ON THE JOB. THE DESIGNER MUST BE NOTIFIED IMMEDIATELY OF ANY VARIATIONS FROM THE DIMENSIONS AND CONDITIONS SHOWN BY THESE DRAWINGS.


NOTE: DISCREPANCY ON ALL DRAWINGS & SPECIFICATIONS (ARCHITECTURAL, STRUCTURAL, SANITARY, ELECTRICAL, MECHANICAL ETC.) SHALL BE SUBJECT FOR VERIFICATION

 
 
NOTE: 1:150 MT. ASK! DO NOT SCALE!

A
AFSS-DC-01 | AFSS-DC-01
GROUND FLOOR SPRINKLER LAYOUT
SCALE : 1:150 MTS.

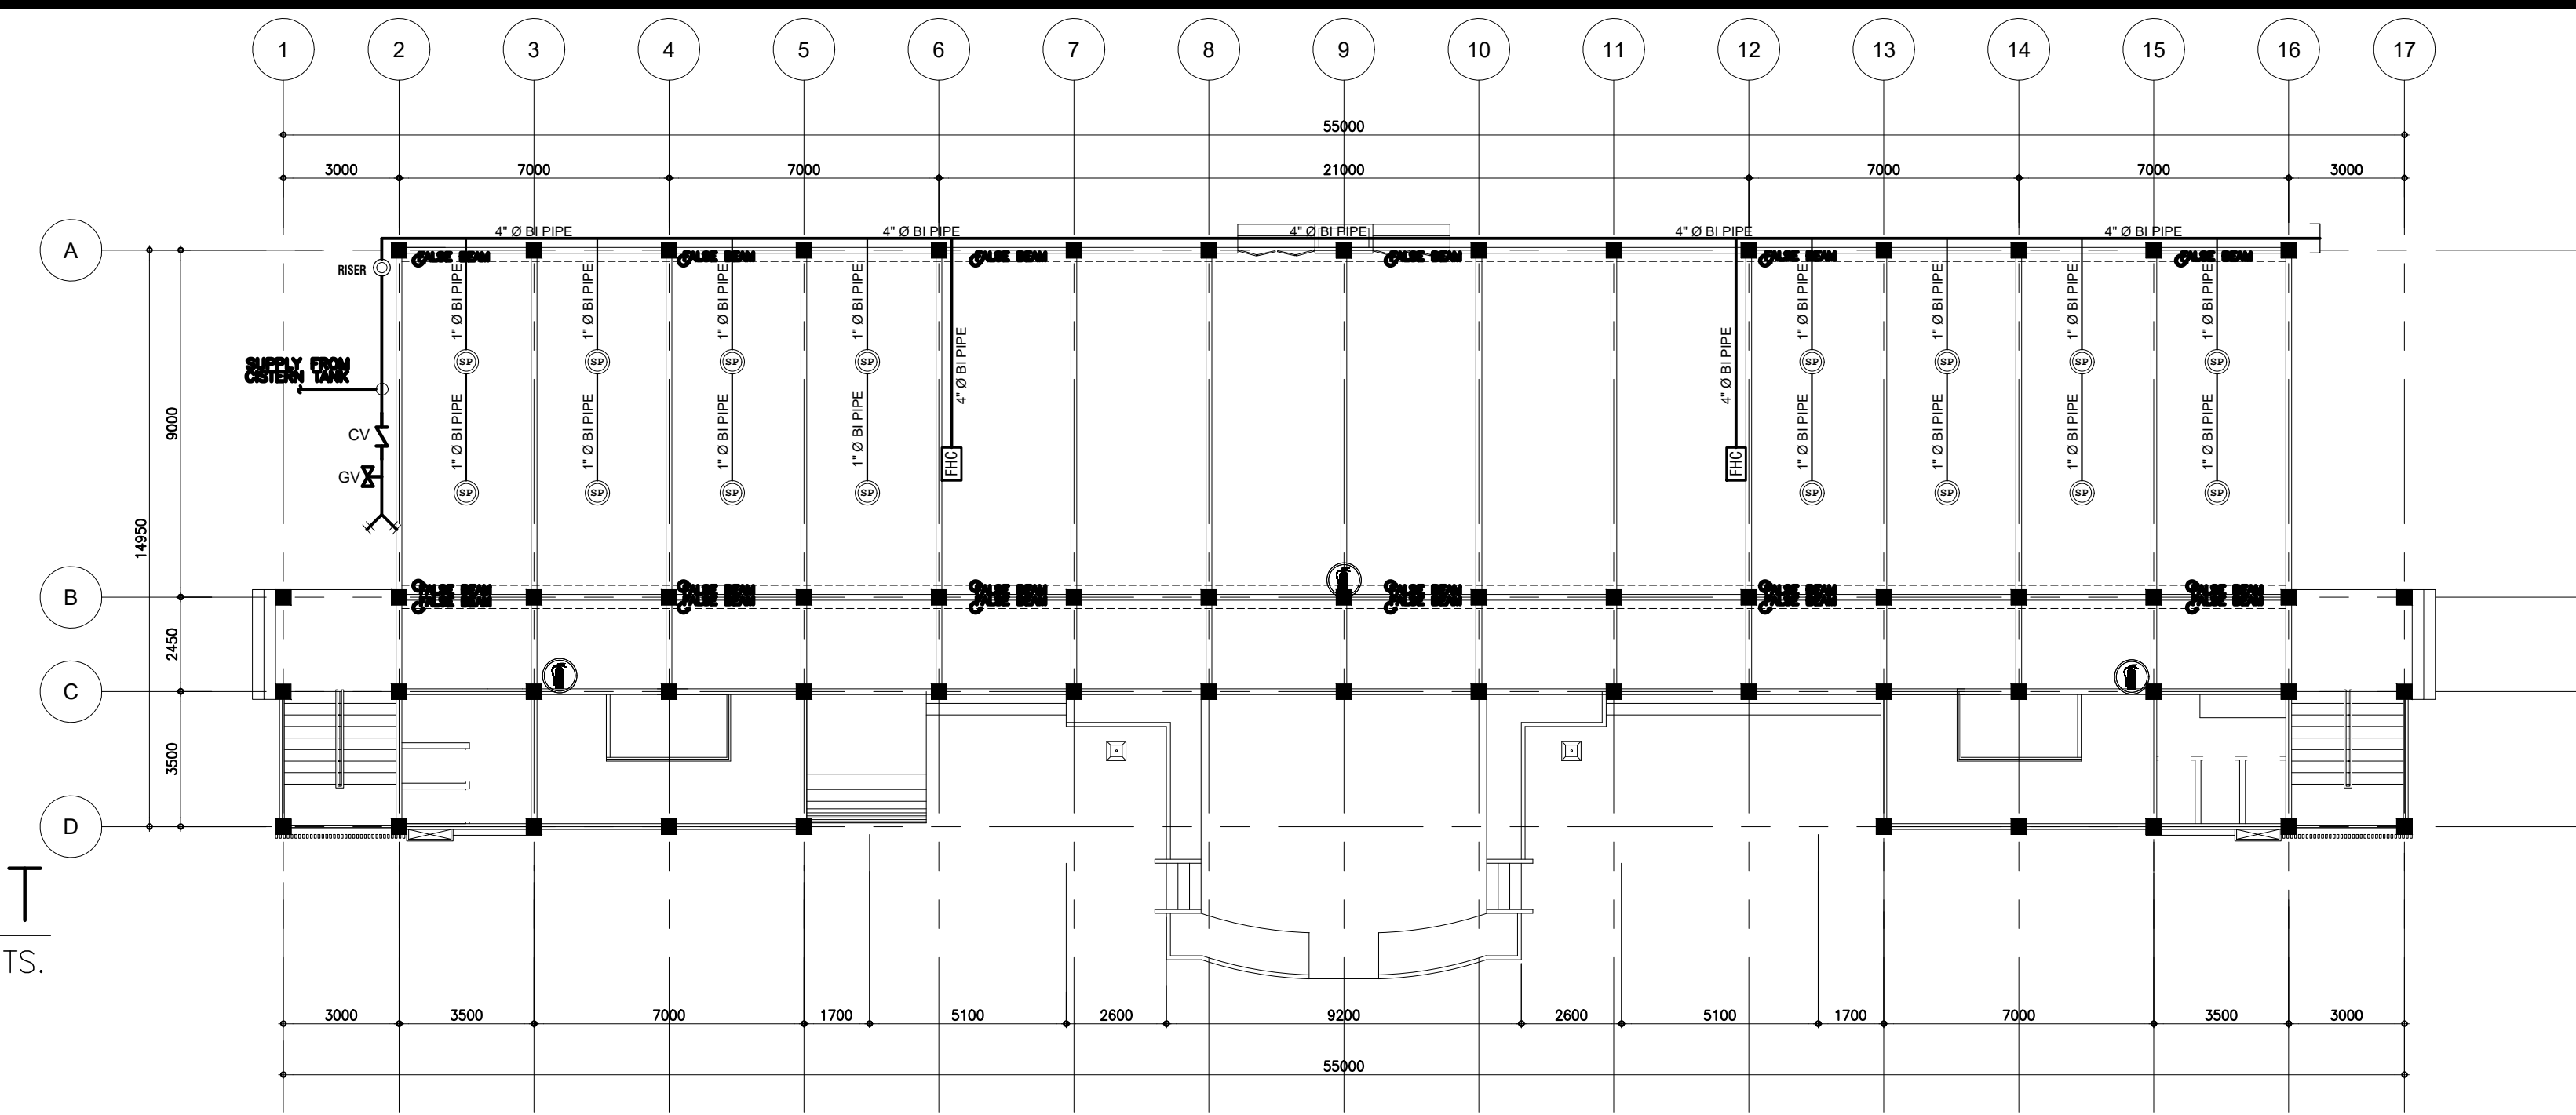

B
AFSS-DC-01 | AFSS-DC-01
GROUND FLOOR SPRINKLER LAYOUT
SCALE : 1:150 MTS.

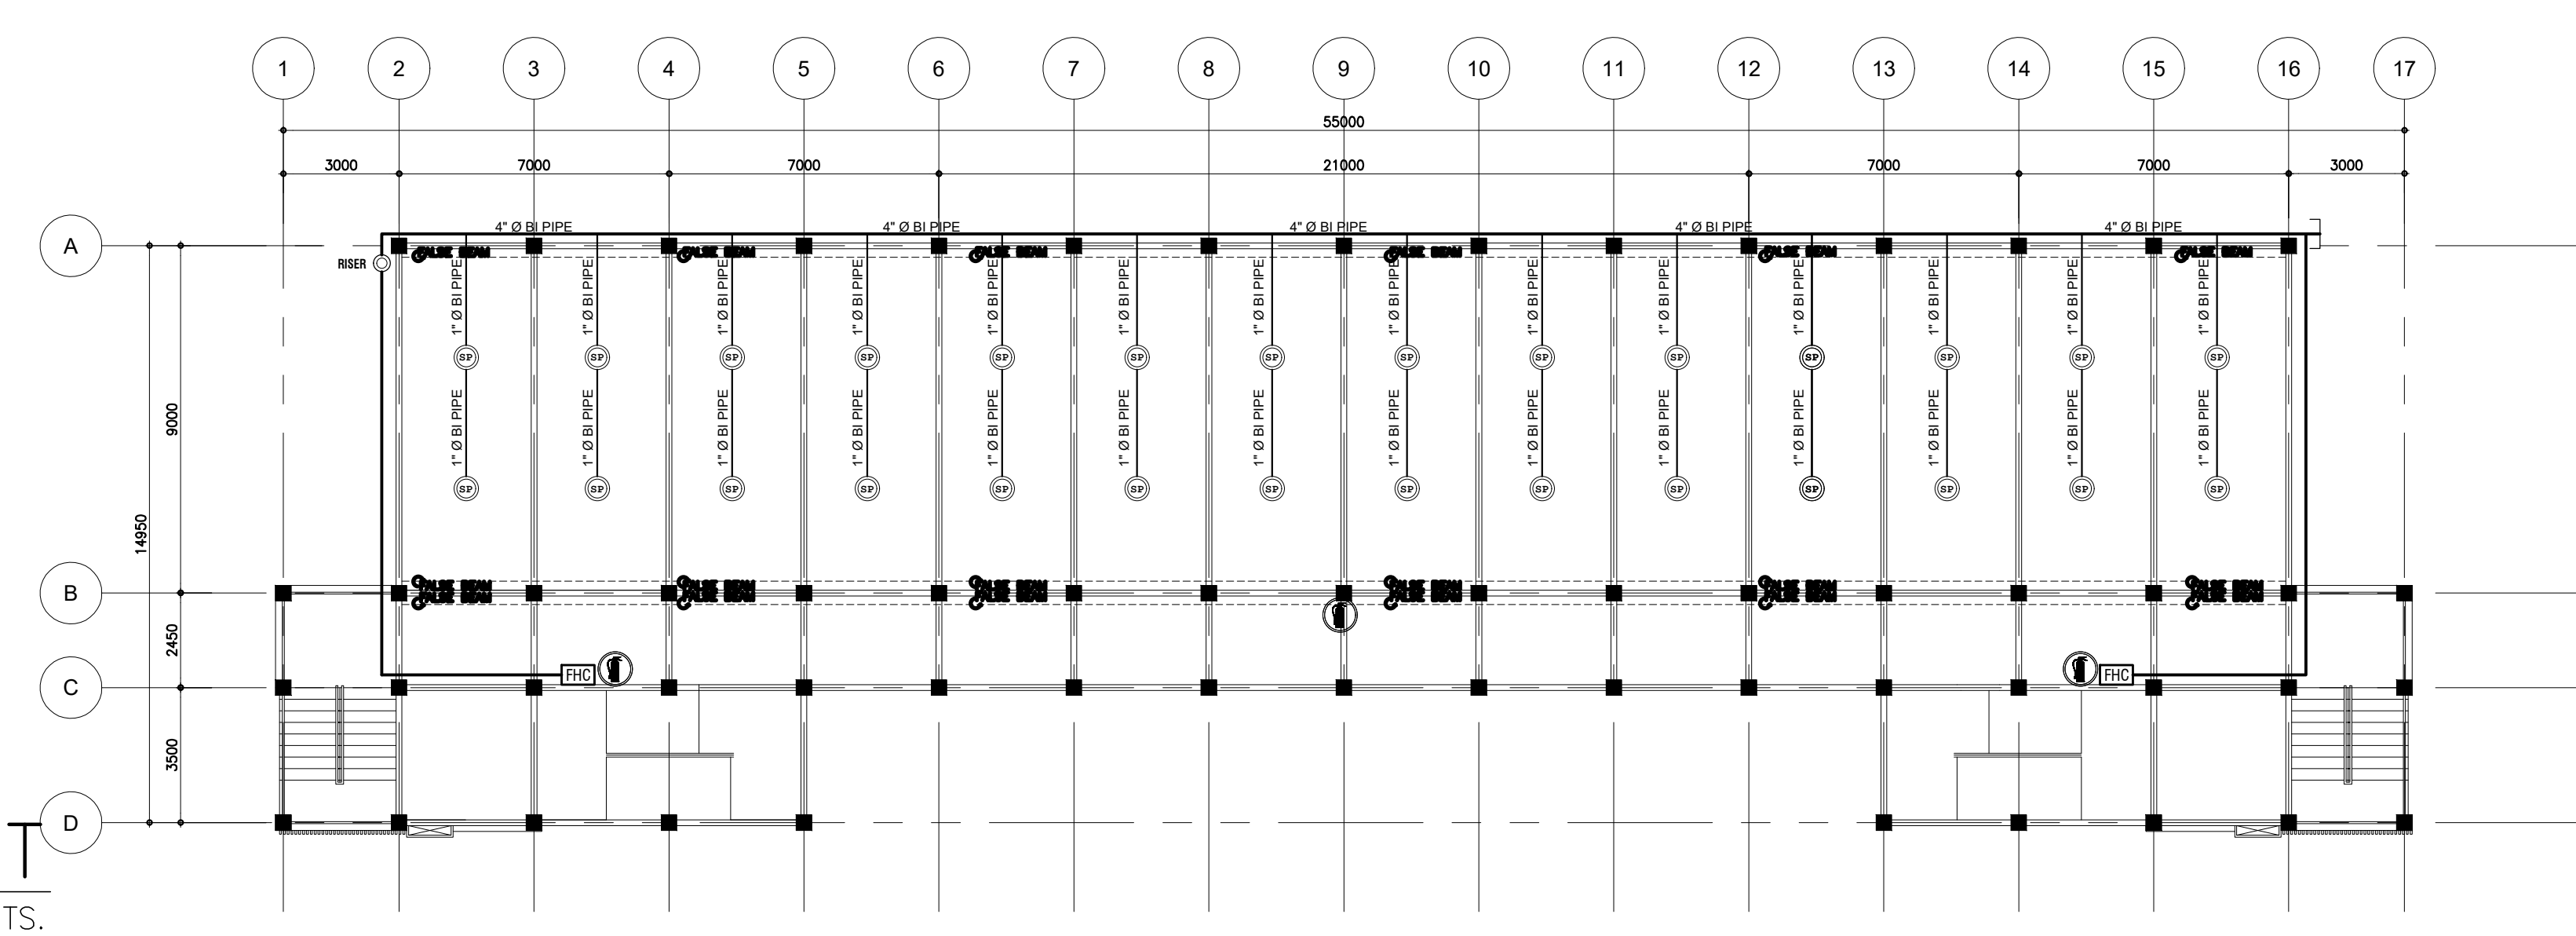

 BATAAN PENINSULA STATE UNIVERSITY TECHNICAL WORKING GROUP FOR INFRASTRUCTURE CAPITOL COMPOUND, BRGY. TENEJERO, CITY OF BALANGA, BATAAN, E-MAIL: bpsu.twginfo2016@gmail.com/ bpsupes2017@gmail.com TELEPHONE NO. : (047) 237-15-98	LEGEND	DESCRIPTION	LEGEND	DESCRIPTION	
		GATE VALVE		STUB OUT	
		CHECK VALVE		PENDENT TYPE SPRINKLER	
	<u>4"Ø B.I. PIPE</u>	4"Ø B.I. PIPE		SIAMESE TWIN	
	<u>1"Ø B.I. PIPE</u>	1"Ø B.I. PIPE		FIRE EXTINGUISHER	
		FIRE HOSE CABINET		RISER	

PROJECT TITLE:
**REPAIR & REHABILITATION OF
ACADEMIC BLDG. II AT DINA-
LUPHAN CAMPUS**

LOCATION:
BATAAN PENINSULA STATE UNIVERSITY
(DINALUPHAN CAMPUS) DINALUPHAN, BATAAN

STRUCTURAL ENGINEER
REG. NO. :
P.R. NO. :
PLACE :
TIN NO. :

MASTER PLUMBER/SANITARY ENGINEER
REG. NO. :
P.R. NO. :
PLACE :
TIN NO. :

PROFESSIONAL ELECTRICAL ENGINEER
REG. NO. :
P.R. NO. :
PLACE :
TIN NO. :

PROFESSIONAL MECHANICAL ENGINEER
REG. NO. :
P.R. NO. :
PLACE :
TIN NO. :

REVISION

NO.	DESCRIPTION	DATE
1		
2		

PREPARED BY:

AR. ROXETTE S. UMEREZ
ARCHITECT 1, BPSU TUG
REG. NO. :
P.R. NO. :
PLACE :
TIN NO. :
REVIEWED BY:

MR. BILLY ALIPIO
CAMPUS DIRECTOR
NOTED BY:

ENGR. ALFREDO D. VALENTOS
DIRECTOR OF PPES
RECOMMENDED BY:

DR. EDMUNDO C. TUNGOL
VICE PRESIDENT ADMIN. & FINANCE
APPROVED BY:

DR. GREGORIO J. RODIS
UNIVERSITY PRESIDENT

REPUBLIC ACT 9266.
NOTE: THIS DRAWING, AS AN INSTRUMENT OF SERVICE
IS THE PROPERTY OF : BATAAN PENINSULA STATE
UNIVERSITY AND AS SUCH MUST NOT BE
REPRODUCED OR COPIED IN PART OR IN WHOLE
WITHOUT THEIR PERMISSION ALL DRAWINGS ARE
TO BE RETURNED WHEN NO LONGER IN USE,

SHEET CONTENT:
GROUND FLOOR
SPRINKLER LAYOUT
SECOND FLOOR
SPRINKLER LAYOUT

SHEET NUMBER:
AFSS-DC-01