




NOTE: ALL DIMENSIONS ON THESE DRAWINGS SHALL HAVE PRECEDENCE OVER SCALED DIMENSIONS. CONTRACTORS SHALL VERIFY AND BE RESPONSIBLE FOR ALL DIMENSIONS AND CONDITIONS ON THE JOB. THE DESIGNER MUST BE NOTIFIED IMMEDIATELY OF ANY VARIATIONS FROM THE DIMENSIONS AND CONDITIONS SHOWN BY THESE DRAWINGS.

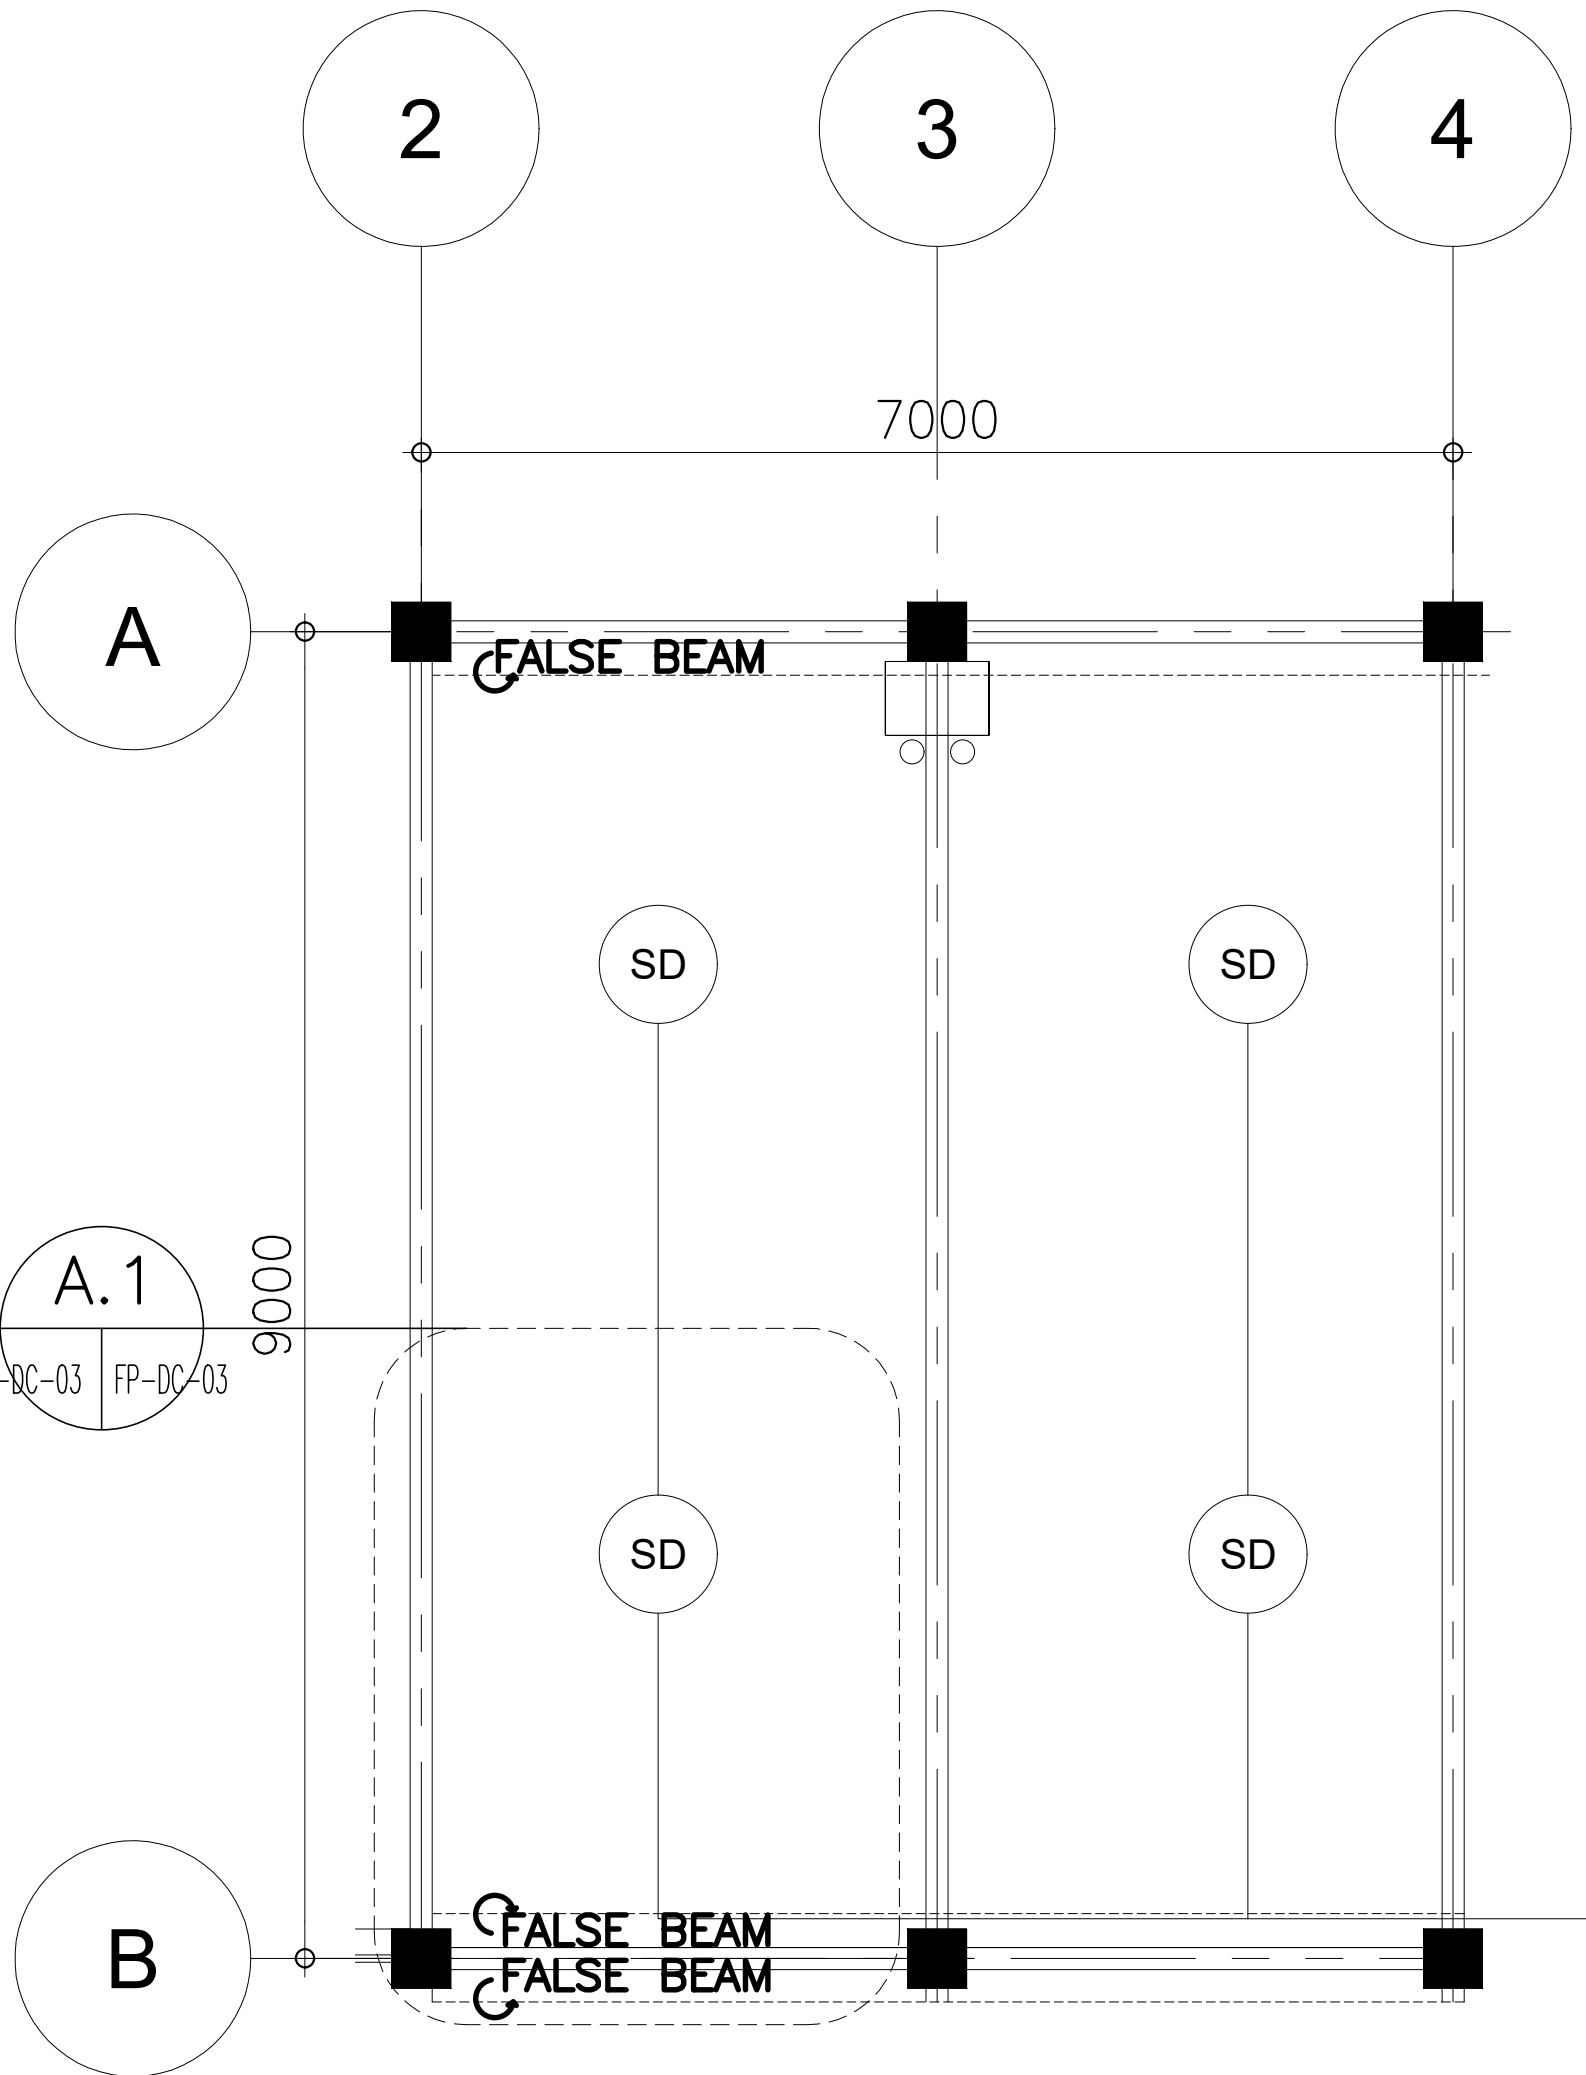


**CLASSROOM (SMOKE DETECTOR) BLOW-UP PLAN**  
SCALE : 1:50 MTS.

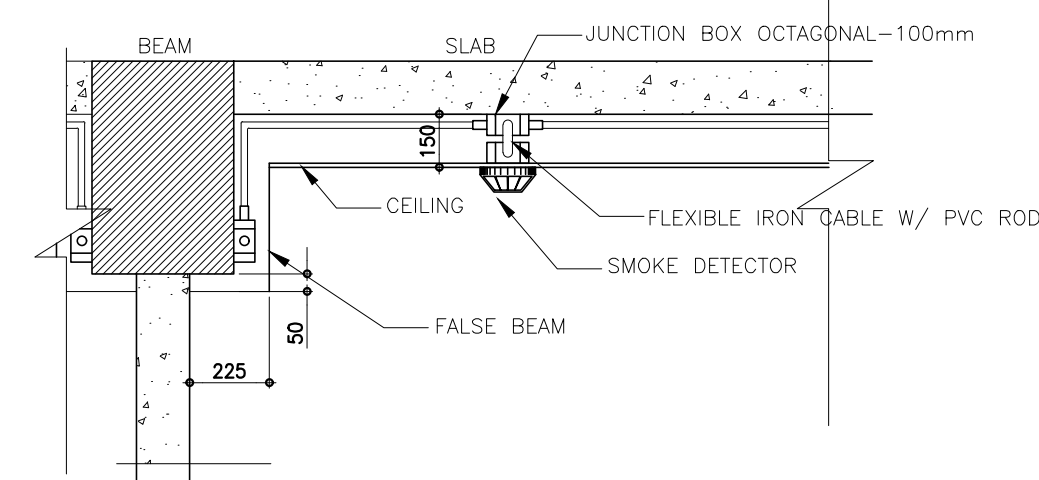


**CLASSROOM (SMOKE DETECTOR) FALSE BEAM SECTION**  
SCALE : NTS.

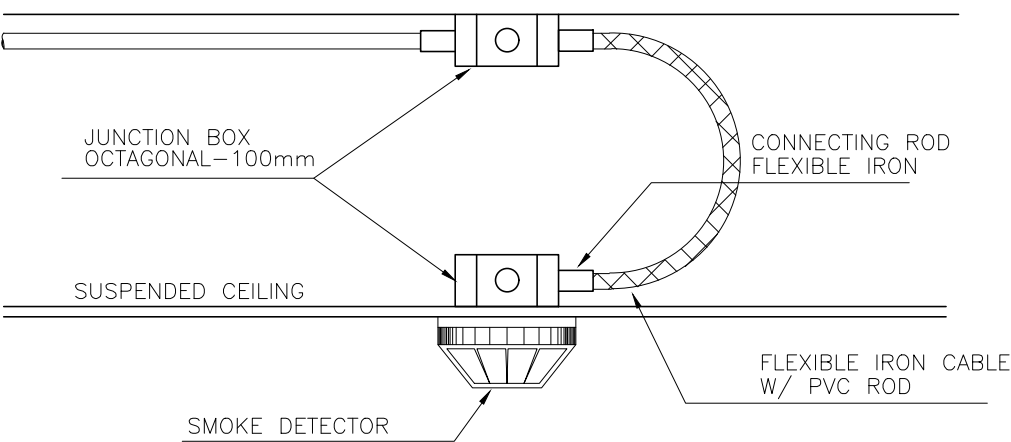


**SMOKE DETECTOR DETAIL**  
SCALE : NTS.

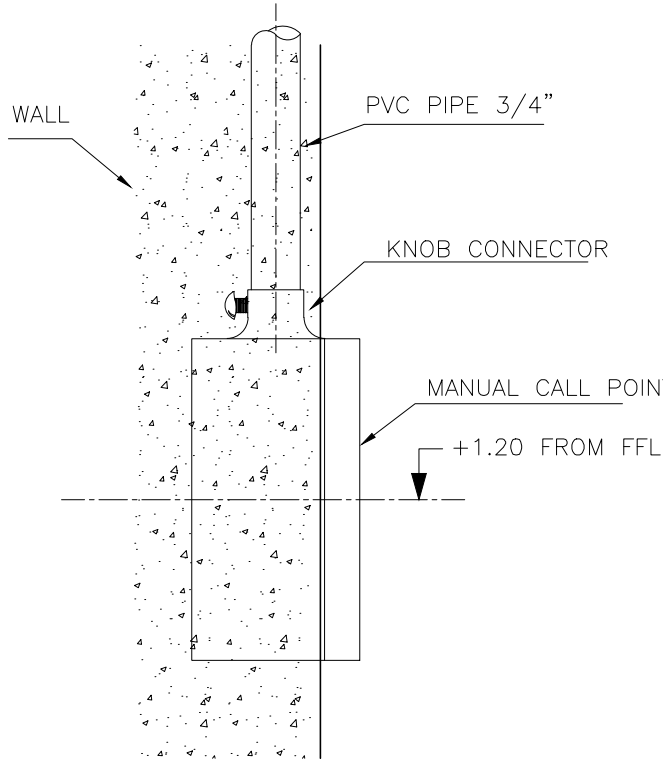

**EMBEDDED MANUAL CALL POINT DETAIL**  
SCALE : NTS.

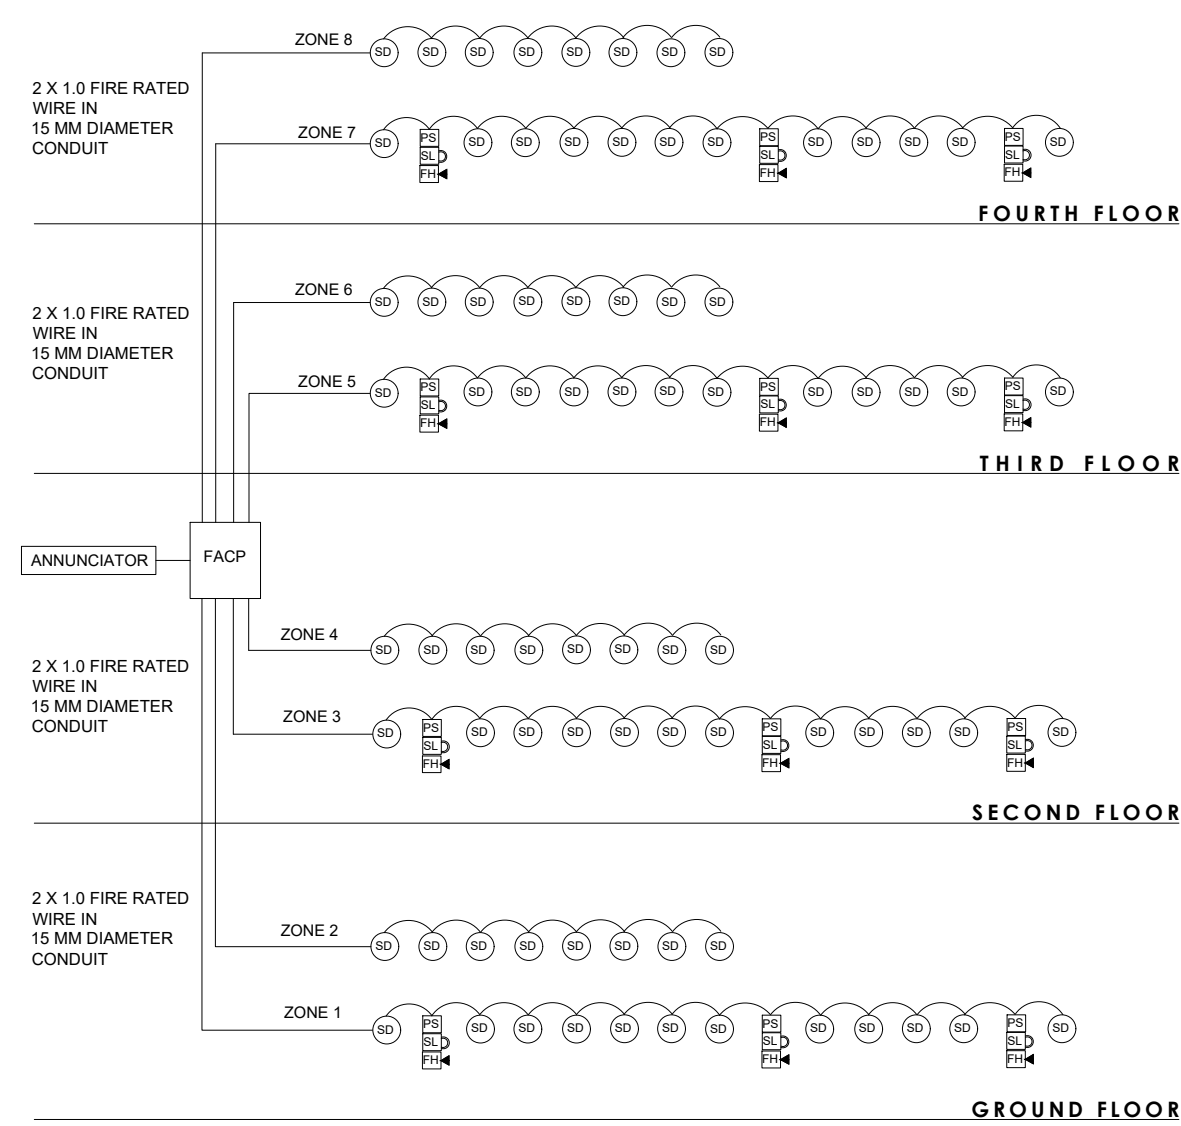

**SINGLE LINE DIAGRAM FDAS LAYOUT**  
SCALE : NTS.

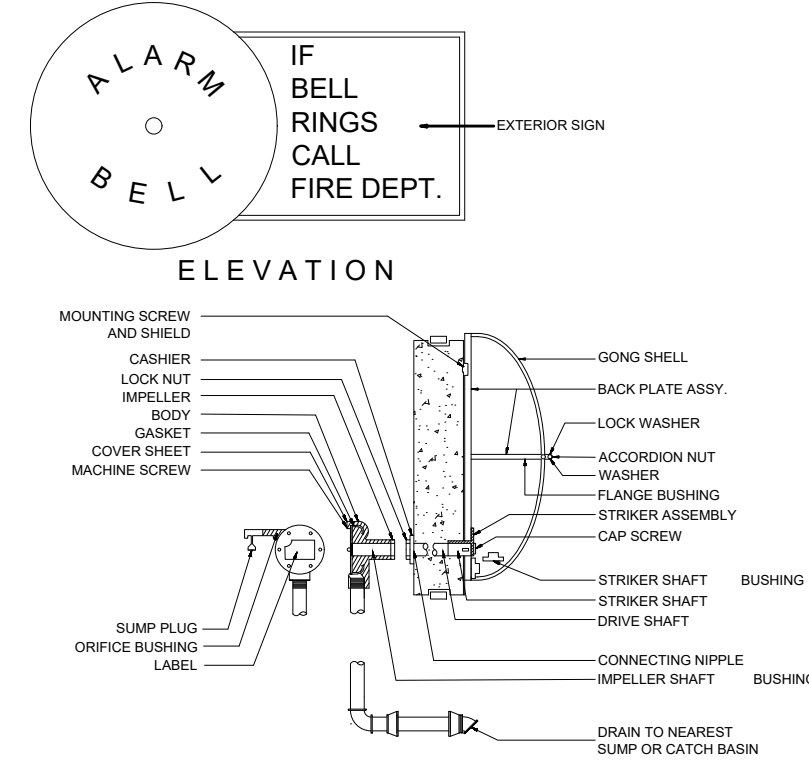

**ALARM MOTOR GANG DETAIL**  
SCALE : NTS.



**BATAAN PENINSULA STATE UNIVERSITY**  
TECHNICAL WORKING GROUP FOR INFRASTRUCTURE

CAPITOL COMPOUND, BRGY. TENEJERO, CITY OF BALANGA, BATAAN,  
E-MAIL: bpsu.twginfo2016@gmail.com / bpsupes2017@gmail.com  
TELEPHONE NO. : (0477) 237-15-98

| LEGEND | DESCRIPTION                  |  |  |
|--------|------------------------------|--|--|
| FACP   | FIRE ALARM AND CONTROL PANEL |  |  |
| SD     | SMOKE DETECTOR               |  |  |
| BELL   | FIRE ALARM BELL              |  |  |
| PS     | PULL STATION                 |  |  |
|        | EMERGENCY LIGHT              |  |  |

PROJECT TITLE:

**REPAIR & REHABILITATION OF ACADEMIC BLDG. II AT DINALUPHAN CAMPUS**

LOCATION:

BATAAN PENINSULA STATE UNIVERSITY (DINALUPHAN CAMPUS) DINALUPHAN, BATAAN

**STRUCTURAL ENGINEER**

REG. NO. :  
P.R. NO. :  
PLACE :  
TIN NO. :

**MASTER PLUMBER/SANITARY ENGINEER**

REG. NO. :  
P.R. NO. :  
PLACE :  
TIN NO. :

**PROFESSIONAL ELECTRICAL ENGINEER**

REG. NO. :  
P.R. NO. :  
PLACE :  
TIN NO. :

**PROFESSIONAL MECHANICAL ENGINEER**

REG. NO. :  
P.R. NO. :  
PLACE :  
TIN NO. :

REVISION

| NO. | DESCRIPTION | DATE |
|-----|-------------|------|
| 1   |             |      |
| 2   |             |      |

PREPARED BY:

**AR. ROXETTE S. UMEREZ**  
**ARCHITECT 1, BPSU TUG**

REG. NO. :  
P.R. NO. :  
PLACE :  
TIN NO. :

REVIEWED BY:

**MR. BILLY ALIPIO**  
**CAMPUS DIRECTOR**

NOTED BY:

**ENGR. ALFREDO D. VALENTOS**  
**DIRECTOR OF PPES**

RECOMMENDED BY:

**DR. EDMUNDO C. TUNGOL**  
**VICE PRESIDENT ADMIN. & FINANCE**

APPROVED BY:

**DR. GREGORIO J. RODIS**  
**UNIVERSITY PRESIDENT**

REPUBLIC ACT 9266.  
NOTE: THIS DRAWING, AS AN INSTRUMENT OF SERVICE IS THE PROPERTY OF : BATAAN PENINSULA STATE UNIVERSITY AND AS SUCH MUST NOT BE REPRODUCED OR COPIED IN PART OR IN WHOLE WITHOUT THEIR PERMISSION ALL DRAWINGS ARE TO BE RETURNED WHEN NO LONGER IN USE.

SHEET CONTENT: **BLOW-UP PLAN FALSE BEAM SECTION SMOKE DETECTOR DETAILS**

SHEET NUMBER: **FP-DC-03**