


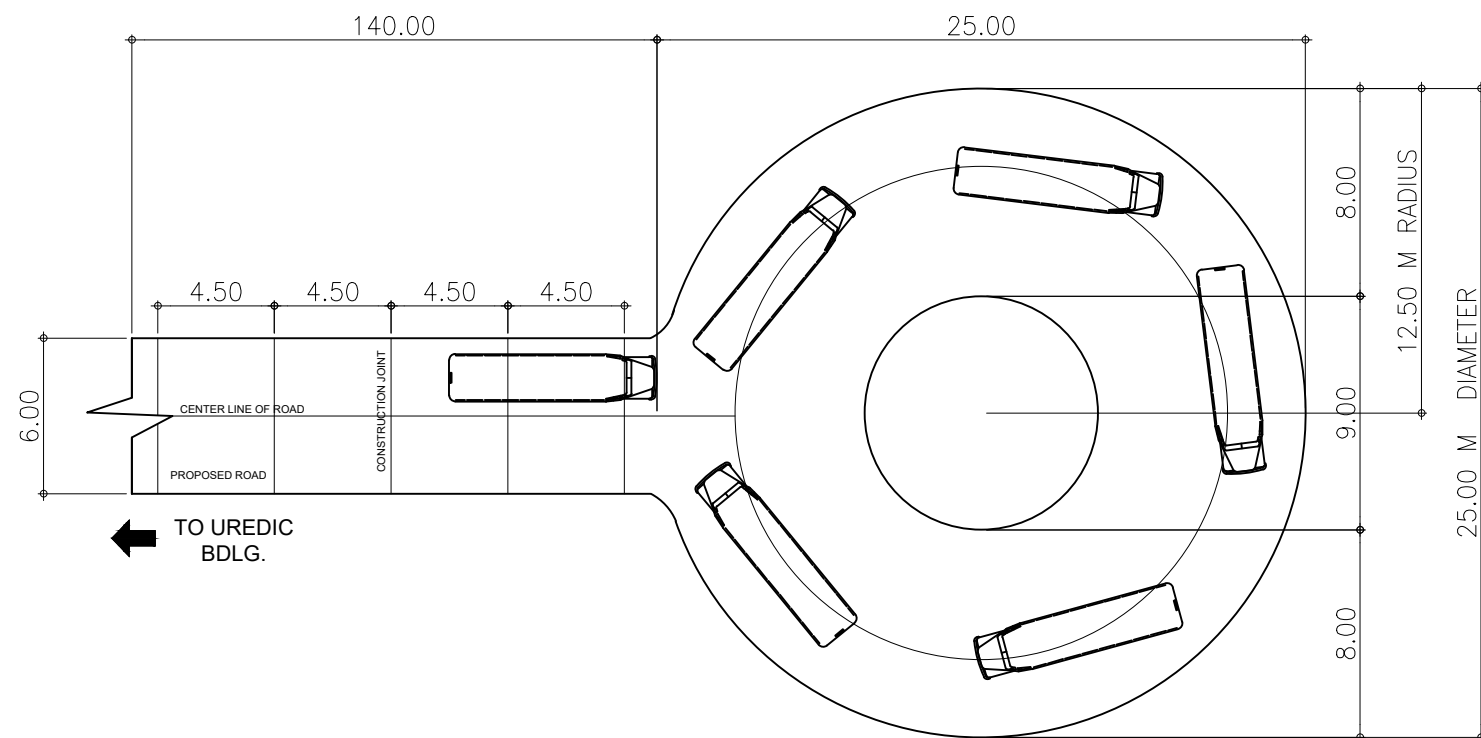


PROPOSED ROAD  
FLOOR PLAN

A

A-AC-01/A-AC-01

SCALE : 1:150 M.

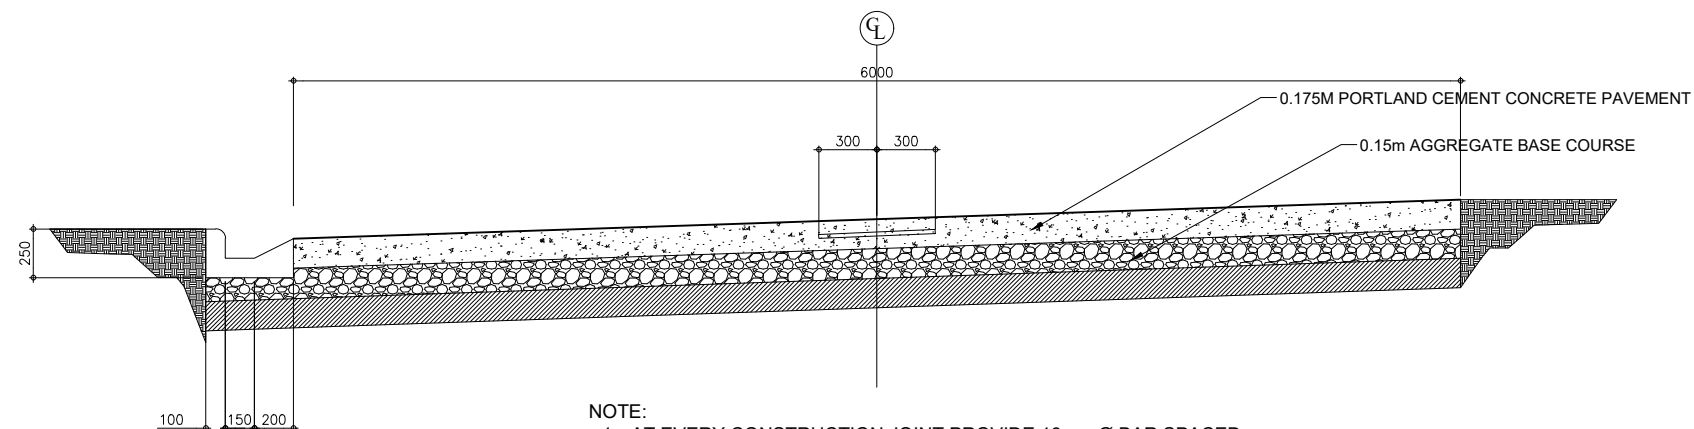

NOTE:  
1. AT EVERY CONSTRUCTION JOINT PROVIDE 16mm Ø BAR SPACED AT 0.60m ON CENTER

B SECTION OF ROAD  
A-AC-01A-AC-01 SCALE : 1:20 M.

NOTE : WRITTEN DIMENSIONS ON THESE DRAWINGS SHALL HAVE PRECEDENCE OVER SCALED DIMENSIONS. CONTRACTORS SHALL VERIFY AND BE RESPONSIBLE FOR ALL DIMENSIONS AND CONDITIONS ON THE JOB. THE DESIGNER MUST BE NOTIFIED IMMEDIATELY OF ANY VARIATIONS FROM THE DIMENSIONS AND CONDITIONS SHOWN BY THESE DRAWINGS.

NOTE : ANY DISCREPANCY ON ALL DRAWINGS & SPECIFICATIONS (ARCHITECTURAL, STRUCTURAL, SANITARY, ELECTRICAL, MECHANICAL ETC.) SHALL BE SUBJECT FOR VERIFICATION

NOTE : IF IN DOUBT, ASK DO NOT SCALE



**BATAAN PENINSULA STATE UNIVERSITY**  
TECHNICAL WORKING GROUP FOR INFRASTRUCTURE

CAPITOL COMPOUND, BRGY. TENEJERO, CITY OF BALANGA, BATAAN,  
E-MAIL: [bpsu.techinfra2016@gmail.com](mailto:bpsu.techinfra2016@gmail.com) / [bpsuppes2017@gmail.com](mailto:bpsuppes2017@gmail.com)  
TELEPHONE NO.: (047) 237-15-98

CAPITOL COMPOUND, BRGY. TENEJERO, CITY OF BALANGA, BATAAN,  
E-MAIL: [bpeu.brginfra2016@gmail.com](mailto:bpeu.brginfra2016@gmail.com)/ [bpaupes2017@gmail.com](mailto:bpaupes2017@gmail.com)  
TELEPHONE NO. : (047) 237-15-98

PROJECT TITLE:

CONSTRUCTION OF ROAD  
NETWORK AND DRAINAGE  
SYSTEM AT BPSU ABUCAY  
CAMPUS

|                                                                     |
|---------------------------------------------------------------------|
| LOCATION:                                                           |
| BATAAN PENINSULA STATE UNIVERSITY (ABUCAY CAMPUS)<br>ABUCAY, BATAAN |

|                     |  |
|---------------------|--|
| STRUCTURAL ENGINEER |  |
| REG. NO :           |  |
| PPL. NO :           |  |
| PLACE :             |  |
| TIN NO :            |  |

|                                  |  |
|----------------------------------|--|
| MASTER PLUMBER/SANITARY ENGINEER |  |
| REG. NO :                        |  |
| PFR. NO :                        |  |
| PLACE :                          |  |
| TIN NO :                         |  |

| PROFESSIONAL ELECTRICAL ENGINEER |  |
|----------------------------------|--|
| REG. NO :                        |  |
| PWR. NO :                        |  |
| PLACE :                          |  |
| TIN NO :                         |  |

|                                  |  |
|----------------------------------|--|
| PROFESSIONAL MECHANICAL ENGINEER |  |
| REG. NO :                        |  |
| PRL NO :                         |  |
| PLACE :                          |  |
| TIN NO :                         |  |

| REVISION |             |      |
|----------|-------------|------|
| NO.      | DESCRIPTION | DATE |
| 2        |             |      |

|              |  |
|--------------|--|
| PREPARED BY: |  |
|--------------|--|

AR. ROXETTE S. UMERIZ  
ARCHITECT 1, BPSU TWG

|             |  |
|-------------|--|
| REG. NO :   |  |
| PIR. NO :   |  |
| PLACE :     |  |
| CHECKED BY: |  |

WALTER G. VALDEZ  
CAMPUS DIRECTOR

|              |  |
|--------------|--|
| REG. NO :    |  |
| FIRL NO :    |  |
| PLACE :      |  |
| REVIEWED BY: |  |

ENGR. ALFREDO D. VALENTOS  
PPES DIRECTOR

RECOMMENDED BY:

DR. EDMUNDO C. TUNGOL  
VICE PRESIDENT ADMIN. & FINANCE

APPROVED BY: \_\_\_\_\_

DR. GREGORIO J. RODIS  
UNIVERSITY PRESIDENT

REPUBLIC ACT 9266.

NOTE: THIS DRAWING, AS AN INSTRUMENT OF SERVICE, IS THE PROPERTY OF : BATAAN PENINSULA STATE UNIVERSITY AND AS SUCH MUST NOT BE REPRODUCED OR COPIED IN PART OR IN WHOLE WITHOUT THEIR PERMISSION ALL DRAWINGS ARE TO BE RETURNED WHEN NO LONGER IN USE.

|                                                                                           |               |
|-------------------------------------------------------------------------------------------|---------------|
| SHEET CONTENT:                                                                            | SHEET NUMBER: |
| <ul style="list-style-type: none"> <li>• FLOOR PLAN</li> <li>• SECTION OF ROAD</li> </ul> | A-AC-01       |