



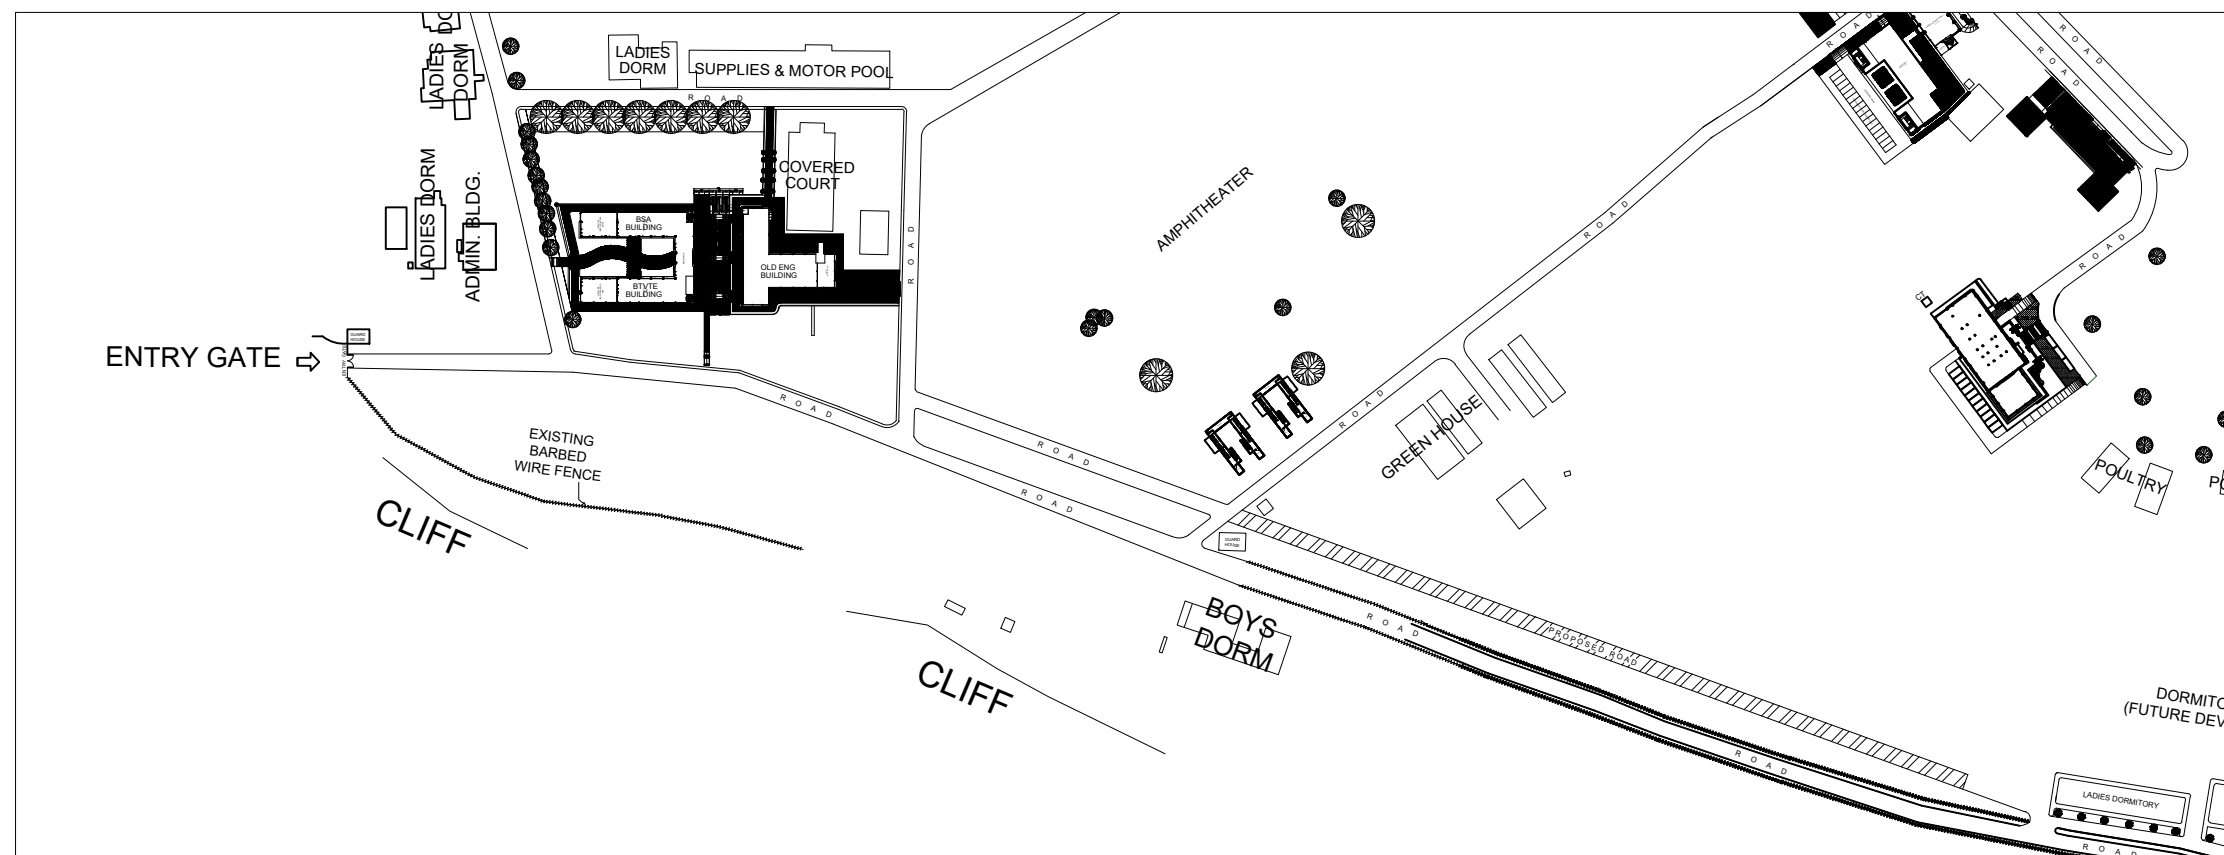

# SITE DEVELOPMENT PLAN

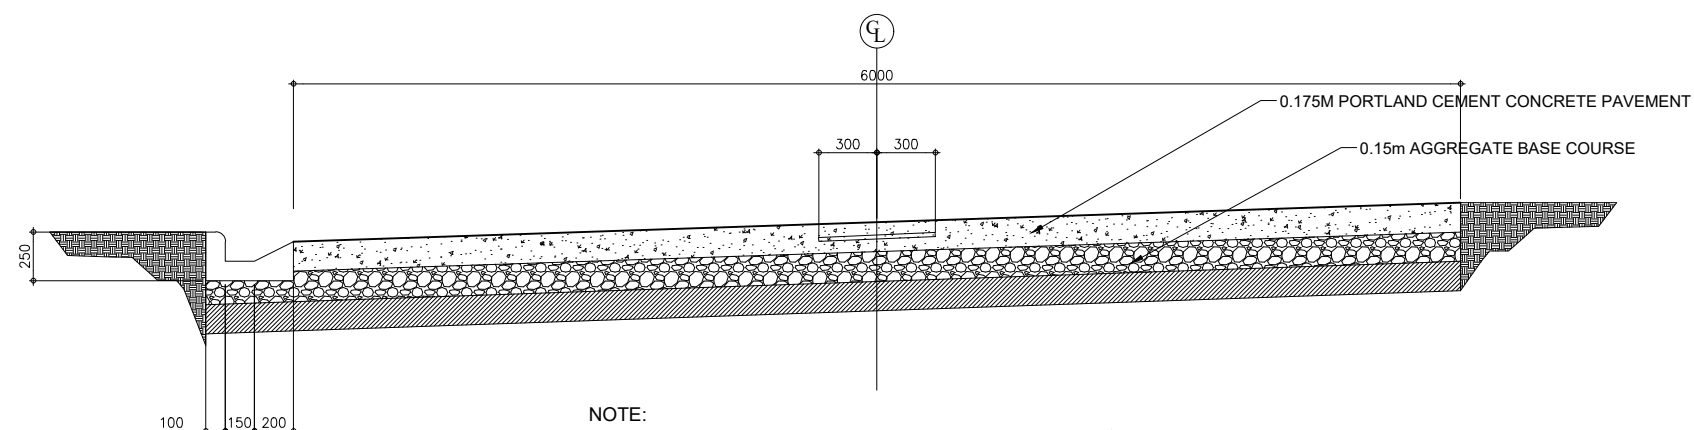

NOTE:  
1. AT EVERY CONSTRUCTION JOINT PROVIDE 16mm Ø BAR SPACED AT 0.60m ON CENTER

# SECTION OF ROAD

SCALE : 1:20 M.

|                |                                                                        |
|----------------|------------------------------------------------------------------------|
| PROJECT TITLE: | CONSTRUCTION OF ROAD NETWORK AND DRAINAGE SYSTEM AT BPSU ABUCAY CAMPUS |
|----------------|------------------------------------------------------------------------|

|                                                                     |
|---------------------------------------------------------------------|
| LOCATION:                                                           |
| BATAAN PENINSULA STATE UNIVERSITY (ABUCAY CAMPUS)<br>ABUCAY, BATAAN |

|                     |  |
|---------------------|--|
| STRUCTURAL ENGINEER |  |
| REG. NO :           |  |
| PR. NO :            |  |
| PLACE :             |  |
| TR. NO :            |  |

|                                  |  |
|----------------------------------|--|
| MASTER PLUMBER/SANITARY ENGINEER |  |
| REG. NO :                        |  |
| FIR. NO :                        |  |
| PLACE :                          |  |
| TEL. NO. :                       |  |

| PROFESSIONAL ELECTRICAL ENGINEER |  |
|----------------------------------|--|
| REG. NO. :                       |  |
| PWR. NO. :                       |  |
| PLACE :                          |  |
| TEL. NO. :                       |  |

|                                  |  |
|----------------------------------|--|
| PROFESSIONAL MECHANICAL ENGINEER |  |
| REG. NO. :                       |  |
| PRG. NO. :                       |  |
| PLACE :                          |  |
| TRA. NO. :                       |  |

| REVISION |             |      |
|----------|-------------|------|
| NO.      | DESCRIPTION | DATE |
| 2        |             |      |

PREPARED BY:

AR. ROXETTE S. UMEREZ

**ARCHITECT 1, BPSU TWC**

|             |  |
|-------------|--|
| REG. NO :   |  |
| PRL. NO :   |  |
| PLACE :     |  |
| CHECKED BY: |  |

WALTER G. VALDEZ

---

CAMPUS DIRECTOR

|              |  |
|--------------|--|
| REG. NO :    |  |
| FIR. NO :    |  |
| PLACE :      |  |
| REVIEWED BY: |  |

ENGR. ALFREDO D. VALENTOS  
PPES DIRECTOR

RECOMMENDED BY: DR. EDMUNDO C. TUNCOI

DR. EDMUNDO C. TUNGOL  
VICE PRESIDENT ADMIN. & FINANCE

APPROVED BY:

DR. GREGORIO J. RODIS  
UNIVERSITY PRESIDENT

REPUBLIC ACT 9266.

NOTE: THIS DRAWING, AS AN INSTRUMENT OF SERVICE IS THE PROPERTY OF : BATAAN PENINSULA STATE UNIVERSITY AND AS SUCH MUST NOT BE REPRODUCED OR COPIED IN PART OR IN WHOLE WITHOUT THEIR PERMISSION ALL DRAWINGS ARE TO BE RETURNED WHEN NO LONGER IN USE,

|                                                                                           |               |
|-------------------------------------------------------------------------------------------|---------------|
| SHEET CONTENT:                                                                            | SHEET NUMBER: |
| <ul style="list-style-type: none"> <li>• FLOOR PLAN</li> <li>• SECTION OF ROAD</li> </ul> | A-AC-01       |

[illegible]

**BATAAN PENINSULA STATE UNIVERSITY**  
TECHNICAL WORKING GROUP FOR INFRASTRUCTURE

CAPITOL COMPOUND, BRGY. TENEJERO, CITY OF BALANGA, BATAAN.  
E-MAIL: [bpuwega2016@gmail.com](mailto:bpuwega2016@gmail.com) / [bpuwega2017@gmail.com](mailto:bpuwega2017@gmail.com)  
TELEPHONE NO.: (047) 237-15-98.

NOTE: WRITTEN DIMENSIONS ON THESE DRAWINGS SHALL HAVE PRECEDENCE OVER SCALED DIMENSIONS. CONTRACTORS SHALL VERIFY AND BE RESPONSIBLE FOR ALL DIMENSIONS AND CONDITIONS ON THE JOB. THE DESIGNER MUST BE NOTIFIED IMMEDIATELY OF ANY VARIATIONS FROM THE DIMENSIONS AND CONDITIONS SHOWN BY THESE DRAWINGS.

NOTE: DISCREPANCY ON ALL DRAWINGS & SPECIFICATIONS (ARCHITECTURAL, STRUCTURAL, SANITARY, ELECTRICAL, MECHANICAL, ETC.) SHALL BE SUBJECT FOR VERIFICATION

NOTE: IF IN LOWER ASK (DO NOT SCALE)