


NOTE : WRITTEN DIMENSIONS ON THESE DRAWINGS SHALL HAVE PRECEDENCE OVER SCALED DIMENSIONS. CONTRACTORS SHALL VERIFY AND BE RESPONSIBLE FOR ALL DIMENSIONS. ANY DISCREPANCY ON ALL DRAWINGS & SPECIFICATIONS SHALL BE THE RESPONSIBILITY OF THE CONTRACTOR. ANY VARIATIONS FROM THE DIMENSIONS AND CONDITIONS SHOWN BY THESE DRAWINGS, SHALL BE SUBJECT FOR VERIFICATION AND APPROVAL BY THE ENGINEER.

NOTE : IF IN DOUBT, ASK FOR CLARIFICATION. DO NOT SCALE!




BATAAN PENINSULA STATE UNIVERSITY
TECHNICAL WORKING GROUP FOR INFRASTRUCTURE
CAPTOL COMPOUND, BRGY. TENILERO, CITY OF BALANGA, BATAAN
E-MAIL: bpsu.tenilero2016@gmail.com/ bpsupps2017@gmail.com
TELEPHONE NO. : (047) 237-15-98

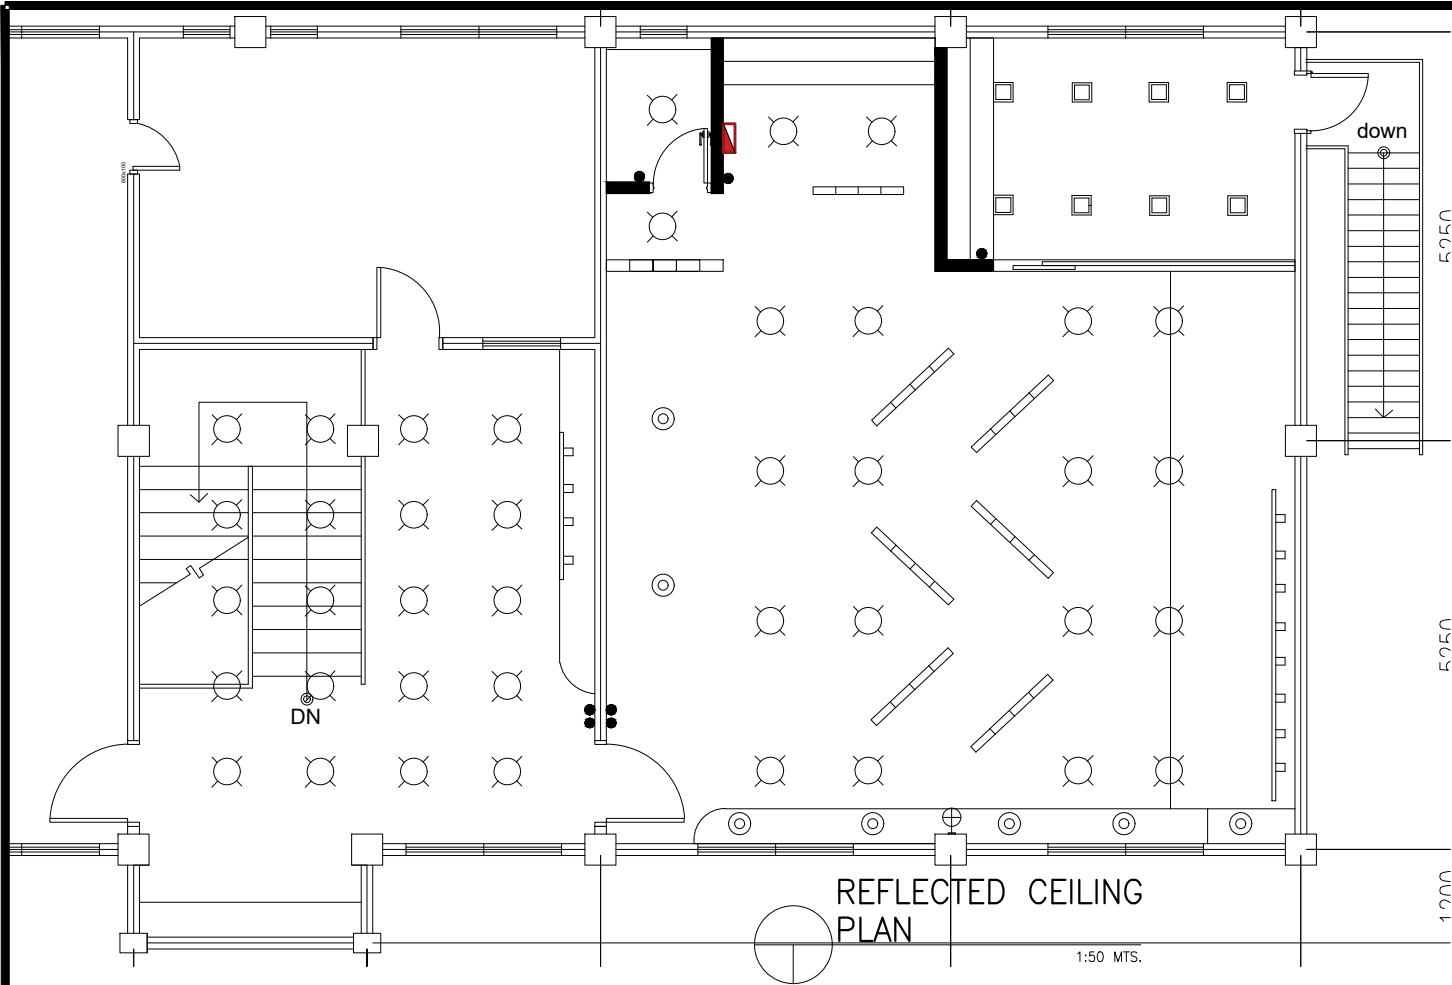


REFLECTED CEILING
PLAN

1:50 MTS.

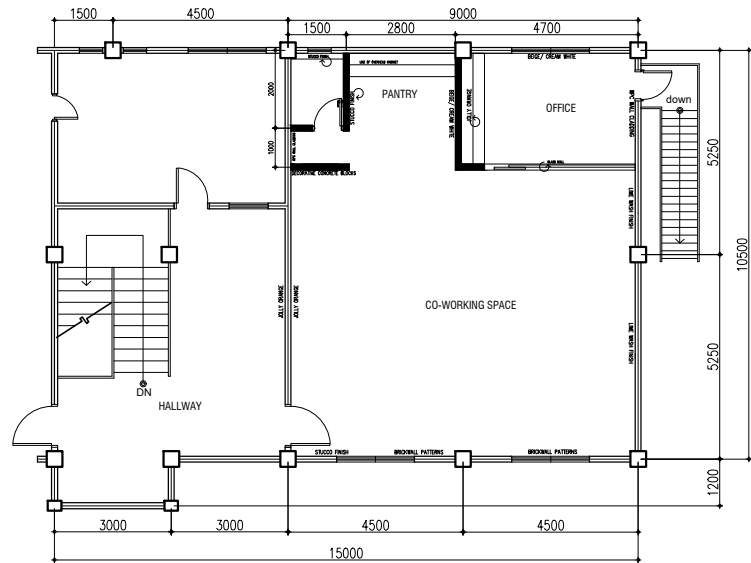


WALL FINISHES
LAYOUT

1:100 MTS.

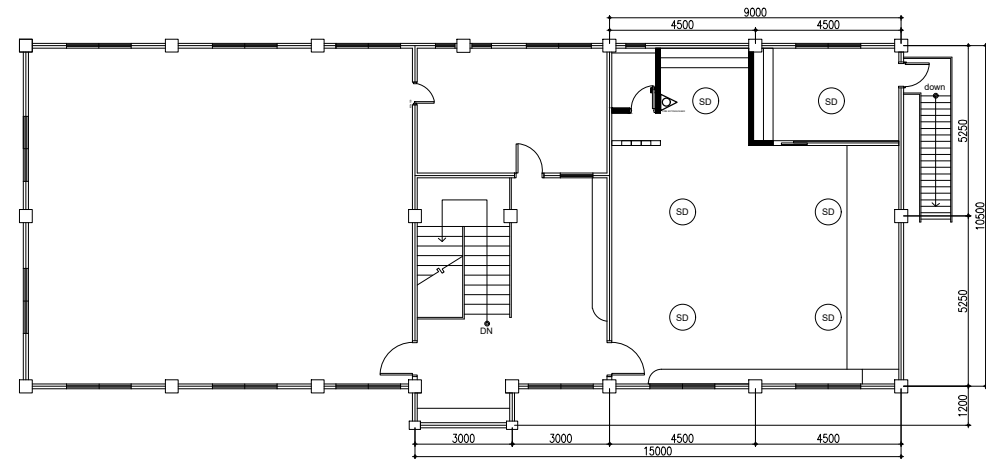

SMOKE DETECTOR
LAYOUT PLAN

SCALE : 1:120 MTS.

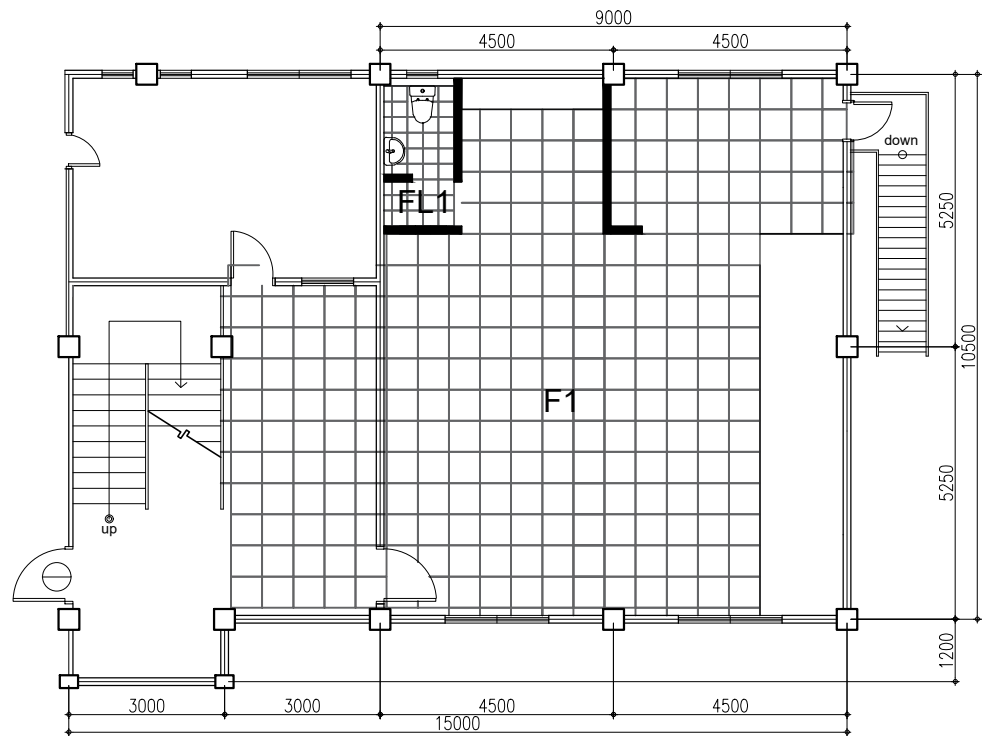

TILE LAYOUT

1:75 MTS.

PROJECT TITLE:

REFURBISHMENT OF
CHEMISTRY LECTURE ROOM
AT BPSU MAIN CAMPUS

LOCATION:
BATAAN PENINSULA STATE UNIVERSITY (MAIN CAMPUS)
CAPTOL COMPOUND, CITY OF BALANGA, BATAAN

STRUCTURAL ENGINEER
REG. NO. :
PTR. NO. :
PLACE :
TN. NO. :

MASTER PLUMBER/SANITARY ENGINEER
REG. NO. :
PTR. NO. :
PLACE :
TN. NO. :

PROFESSIONAL ELECTRICAL ENGINEER
REG. NO. :
PTR. NO. :
PLACE :
TN. NO. :

PROFESSIONAL MECHANICAL ENGINEER
REG. NO. :
PTR. NO. :
PLACE :
TN. NO. :

REVISION		
NO.	DESCRIPTION	DATE

PREPARED BY:

AR. SHARON R. BAUTISTA
ARCHITECT

REVIEWED BY:

ENGR. ROY JOSEPH P. ENRIQUEZ
DIRECTOR OF PPES

RECEIVED BY:

JOERALD M. GADIA, MAPhilo
VICE PRESIDENT ADMIN & FINANCE

APPROVED BY:

DR. RUBY B. SANTOS-MATIBAG
UNIVERSITY PRESIDENT

REPUBLIC ACT 9266.

NOTE: THIS DRAWING, AS AN INSTRUMENT
OF SERVICE IS THE PROPERTY OF :
BATAAN PENINSULA STATE UNIVERSITY
AND AS SUCH MUST NOT BE REPRODUCED
OR COPIED IN PART OR IN WHOLE
WITHOUT THEIR PERMISSION ALL
DRAWINGS ARE TO BE RETURNED WHEN
NO LONGER IN USE.

SHEET CONTENT:	SHEET NUMBER:
- FDAS - REFLECTED CEILING PLAN - WALL FINISHES LAYOUT - TILE LAYOUT	